


Ductwork Layout for Oskar Unit

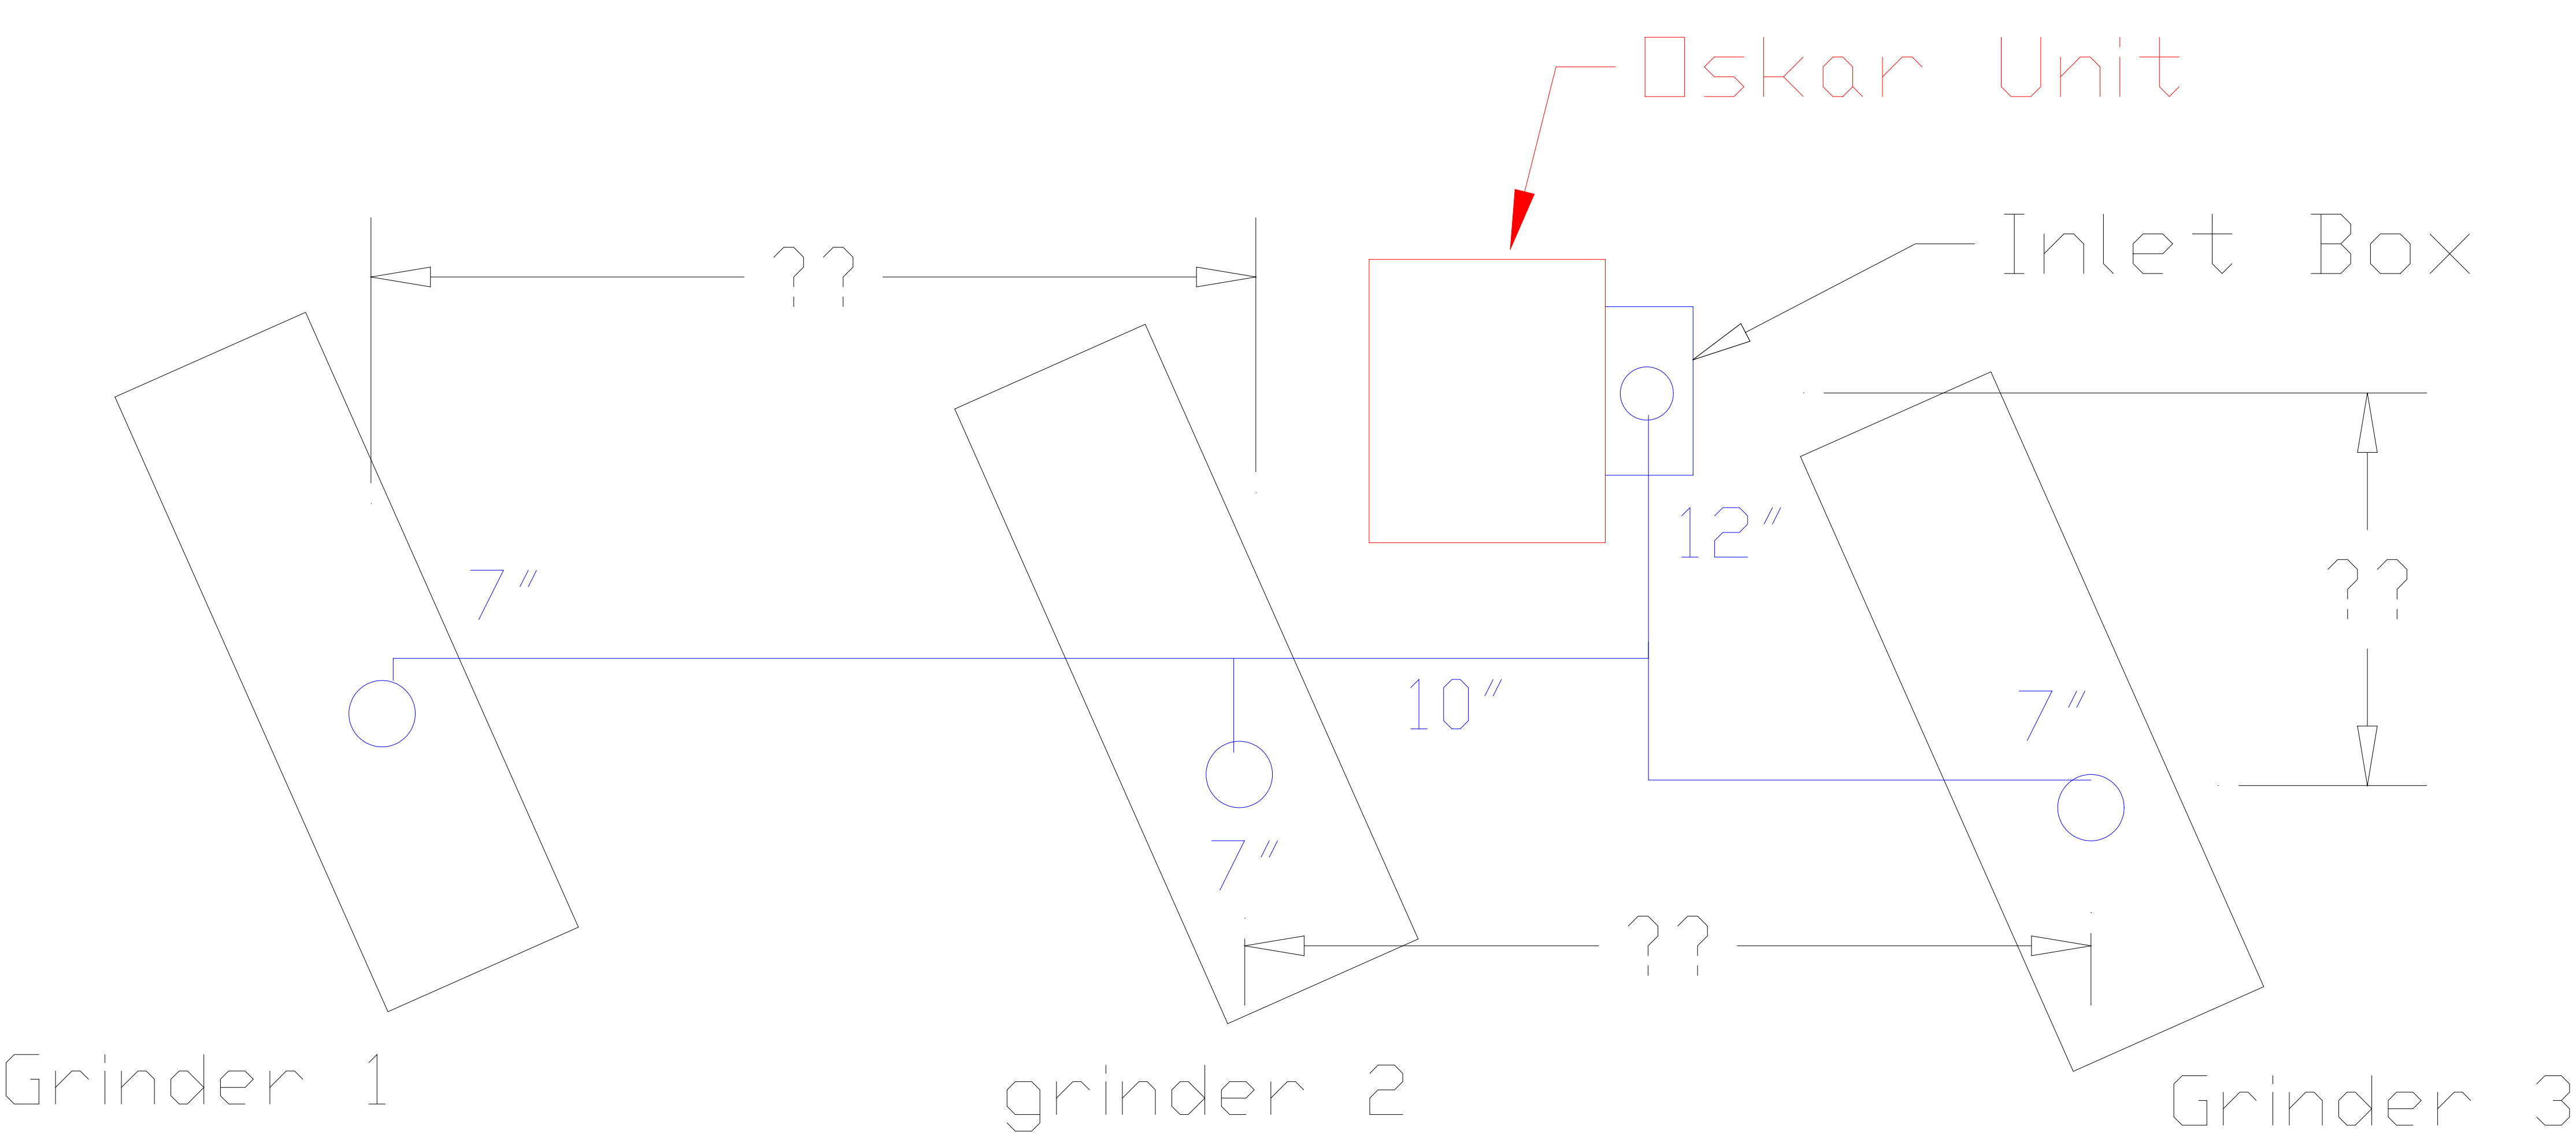

Questions:

- 1. Do you want the ductwork to run below the ceiling or above? What is your ceiling height?
- 2. What size connection is on each grinder? I am trying to determine the part I need to connect to each machine. Is there a flange on the machine? If not what is. Can you take a picture.
- 3. Can you fill in the dmensions on the drawing above.
- 4. Electrical reqirements. Do you want 120 volt or 220 volt single phase? Please let me know so I can make sure the unit has the correct motor.

Industrial Air Quality	
102 AG DRIVE	
Youngsville, NC 27596	
P# 919-562-7181	F# 919-562-7182
Project: Becton Dickson	
Drawing: Oskar Duct layout	
Date: 11/30/07	Drawn by: RAV
Sheet No:	