
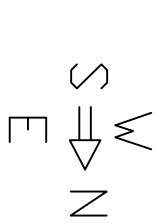


Plan View Ductwork Layout for Bridge Bay

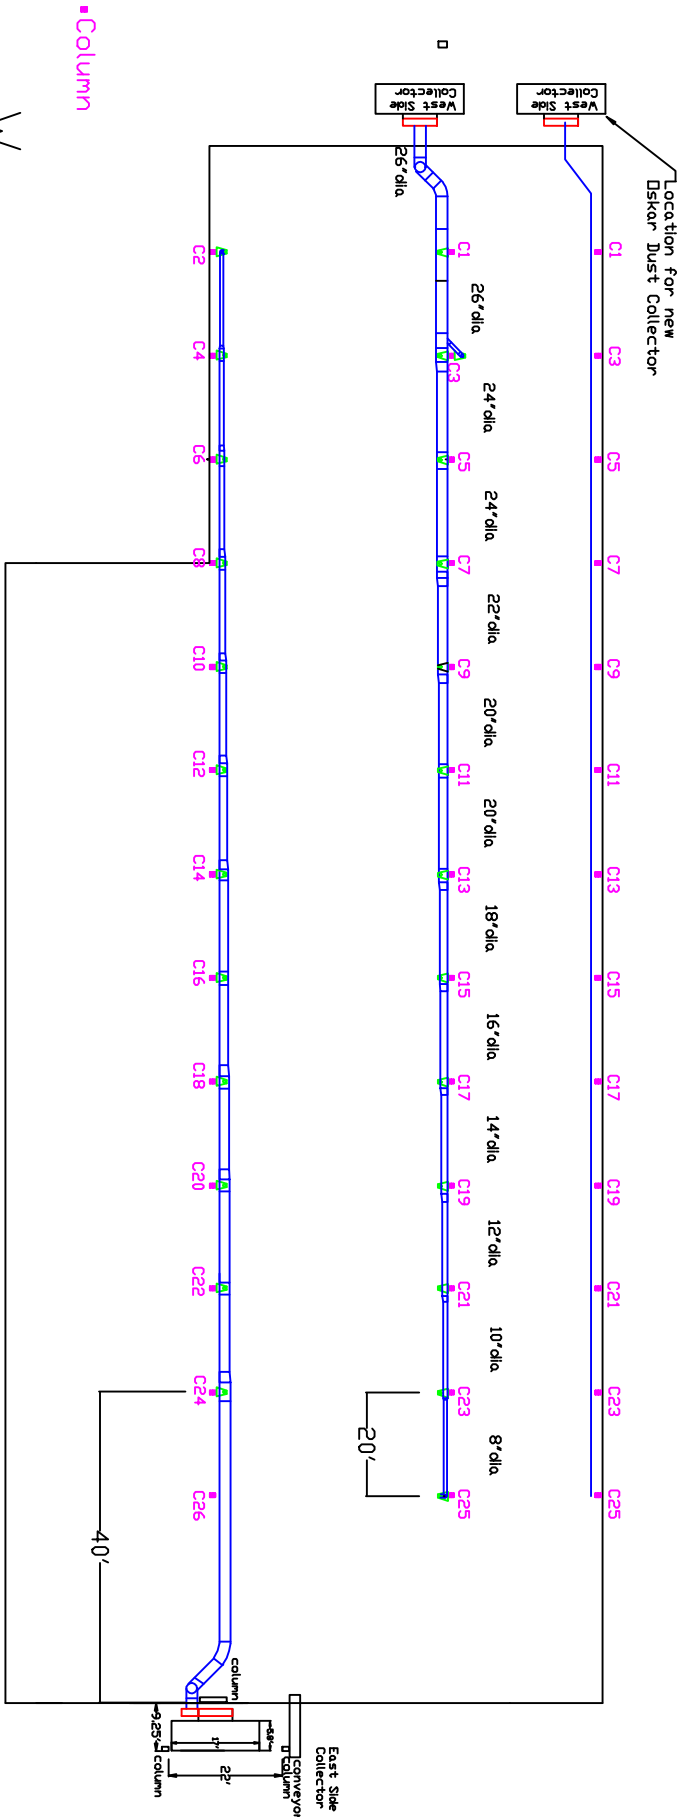

Notes:
A) All drops will be 8" diameter and have an Dskar fume arm 8" dia by 14' long.
B) All Reducers are Eccentric so you can move the center line of the main trunkline towards to column.

DELOR Air Products
3651 ROUTE 2756
Youngsville, NC 27556

OSKAR

Project: Roscoe - Billings
Drawing: Bridge Bay duct
Date: 2/1/10 | Drawn by: RAV

Ductwork Layout Billings