


Ducwork Layout for Oskar Hose Reels

Plan View

Note:

Each Hose Reel will have
500 to 600 CFM's

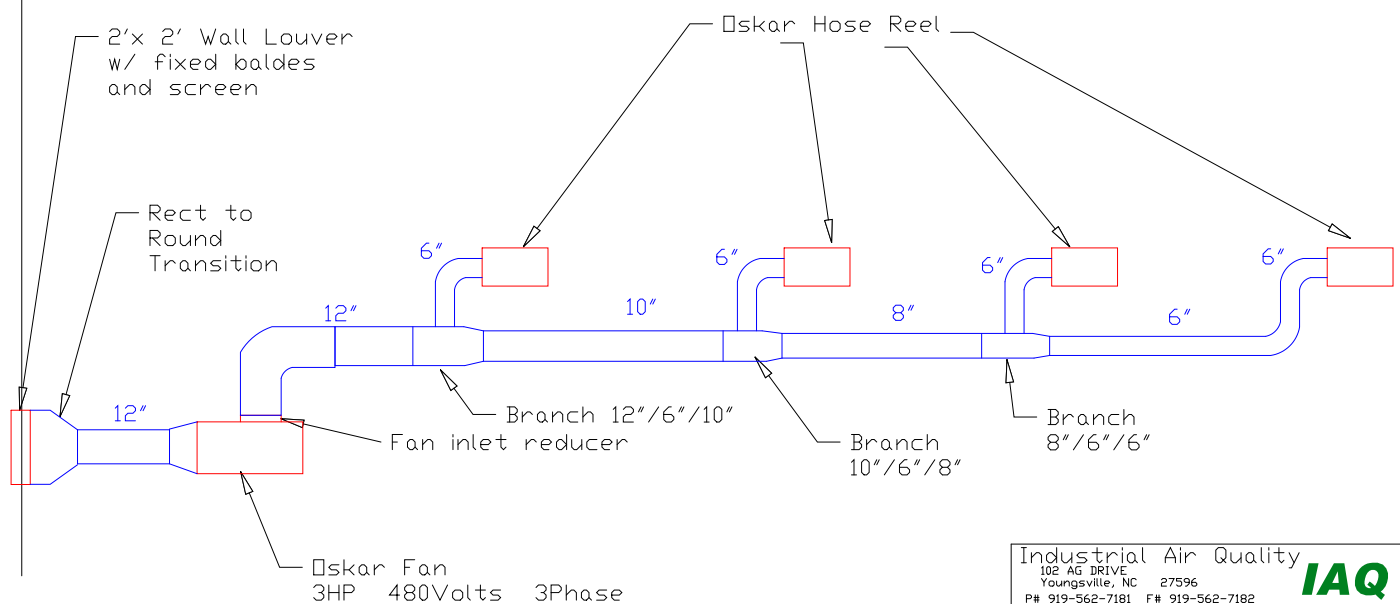

Industrial Air Quality	
102 AG DRIVE	
Youngsville, NC 27596	
P# 919-562-7181	F# 919-562-7182
Project: Triangle Contr.	
Drawing: Ductwork layout	
Date: 7/10/08	Drawn by: RAV
Revision Date:	

IAQ