


# Absolent Ductwork Layout

## Side View

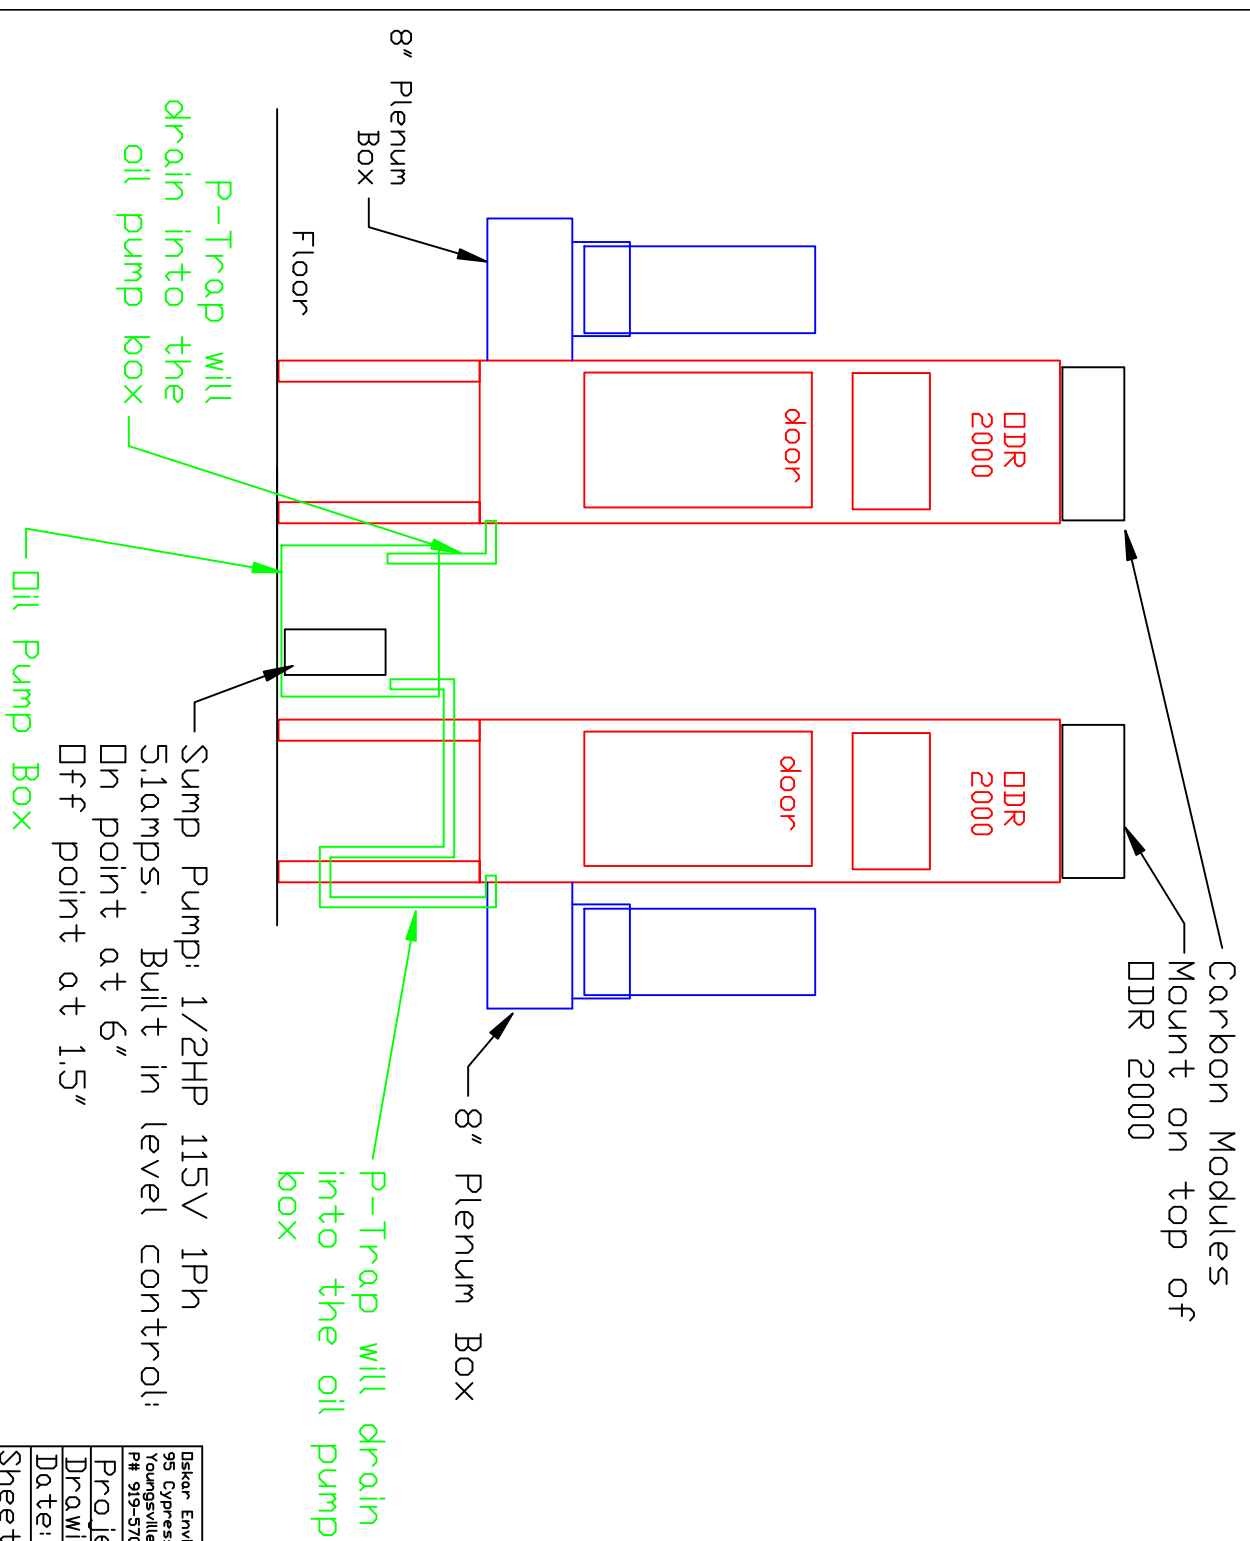

Oskar Environmental Products  
95 Cypress Drive 27596  
Youngsville, NC  
# 919-570-2862 F# 919-570-2863

**Oskar**

Project: Accellent  
Drawing: Ductwork layout  
Date: 7/15/10 | Drawn by: RAV  
Sheet No: