



Absolent Ductwork Layout

Plan View

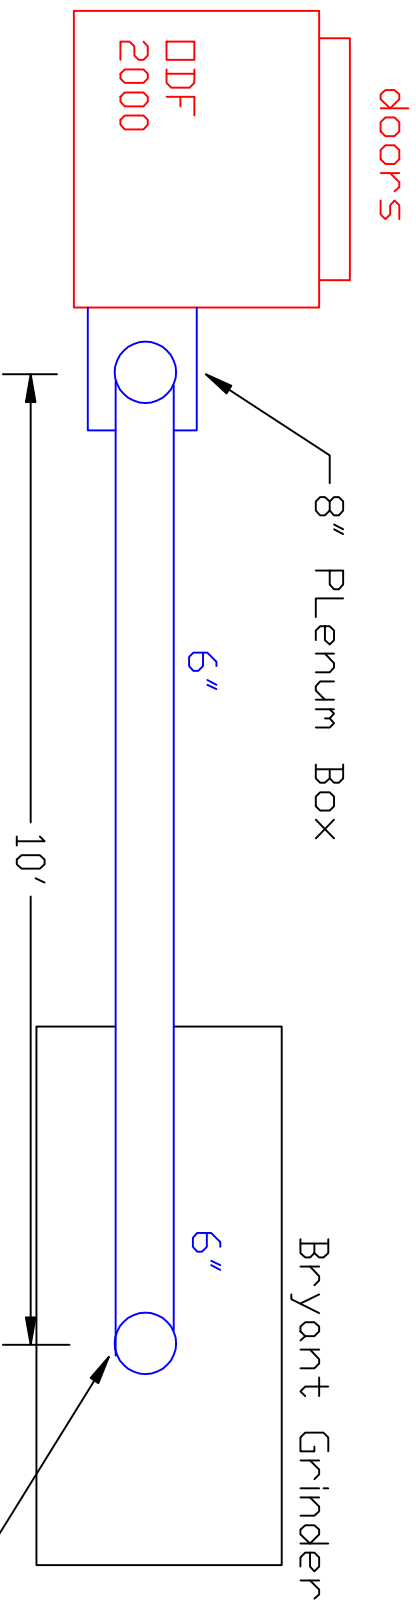

Side View of Inlet Plenum

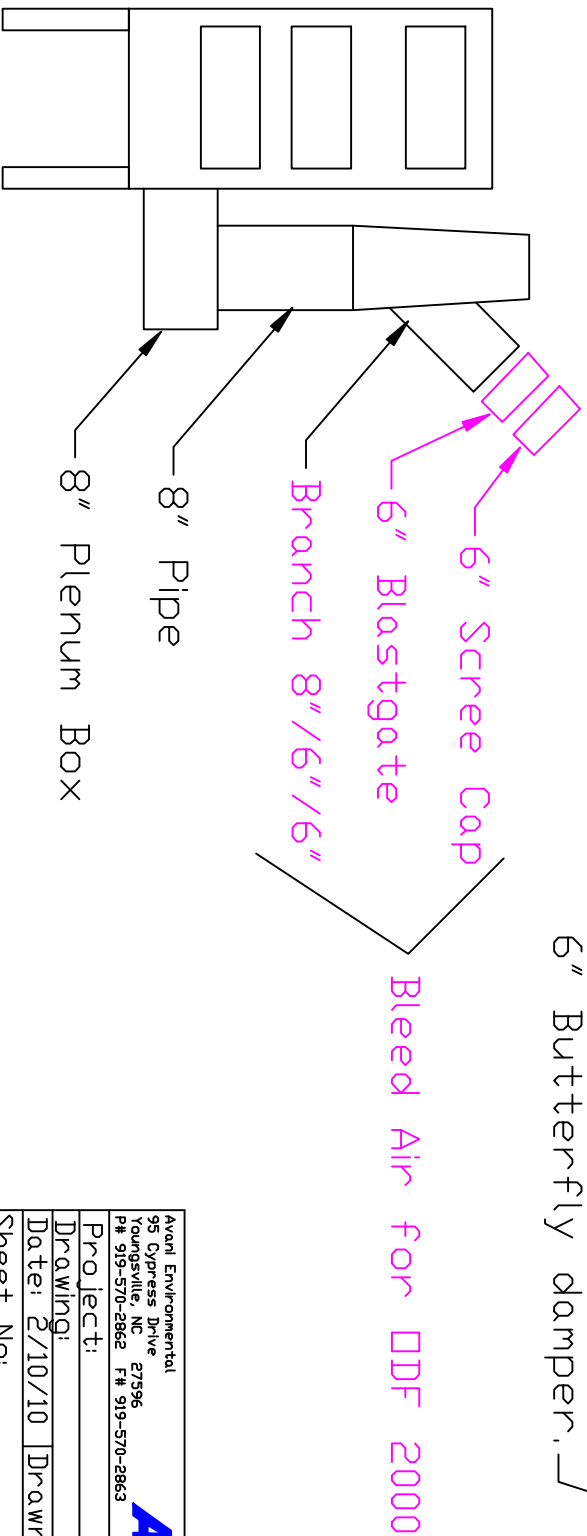

Avanti Environmental 95 Cypress Drive 27596 Raleighville, NC P# 919-570-2862 F# 919-570-2863
Avani
Project:
Drawing:
Date: 2/10/10 Drawn by: RAV
Sheet No: