



Ductwork layout for DDF 2000

Plan View

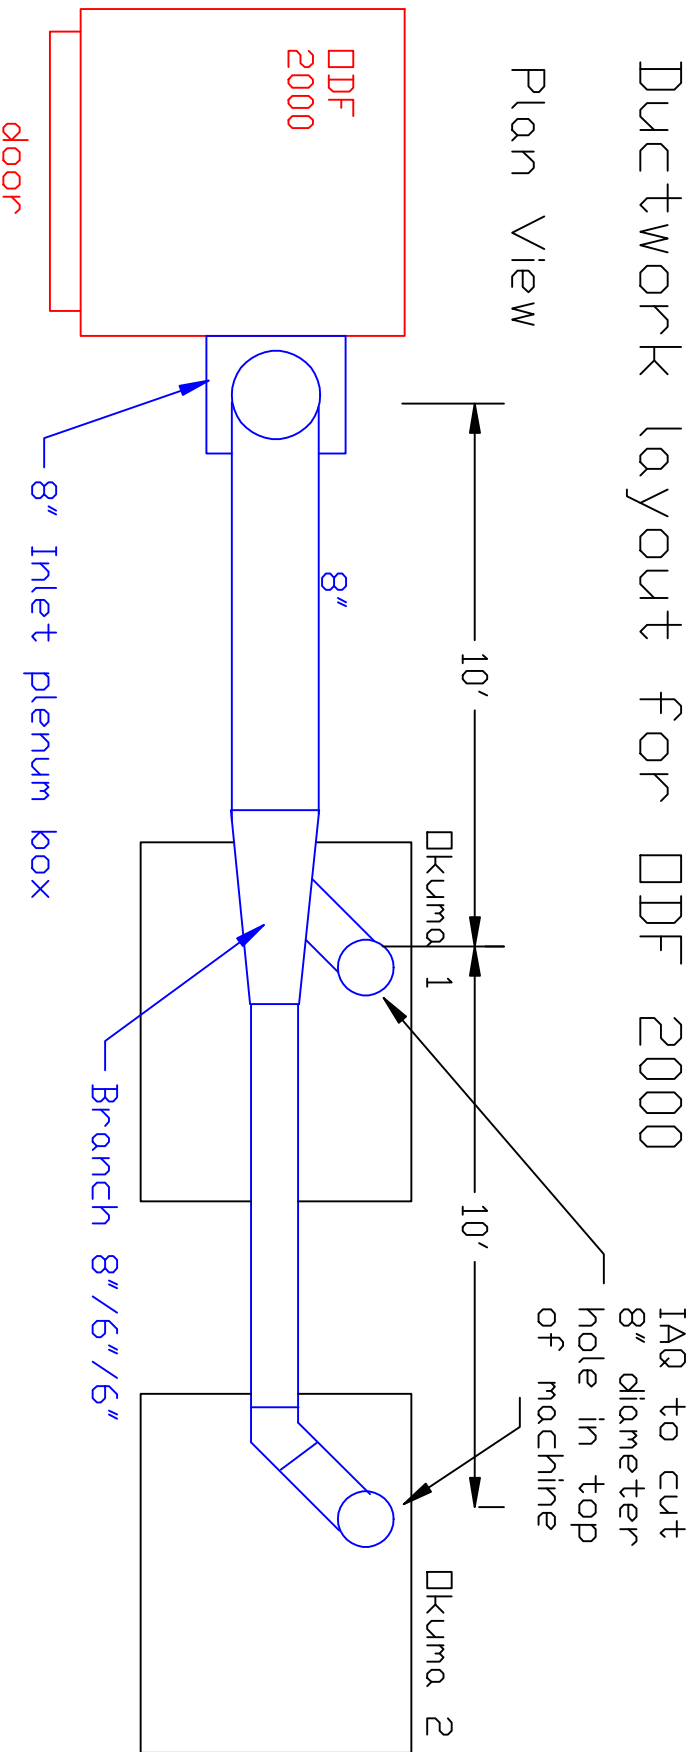

Side View

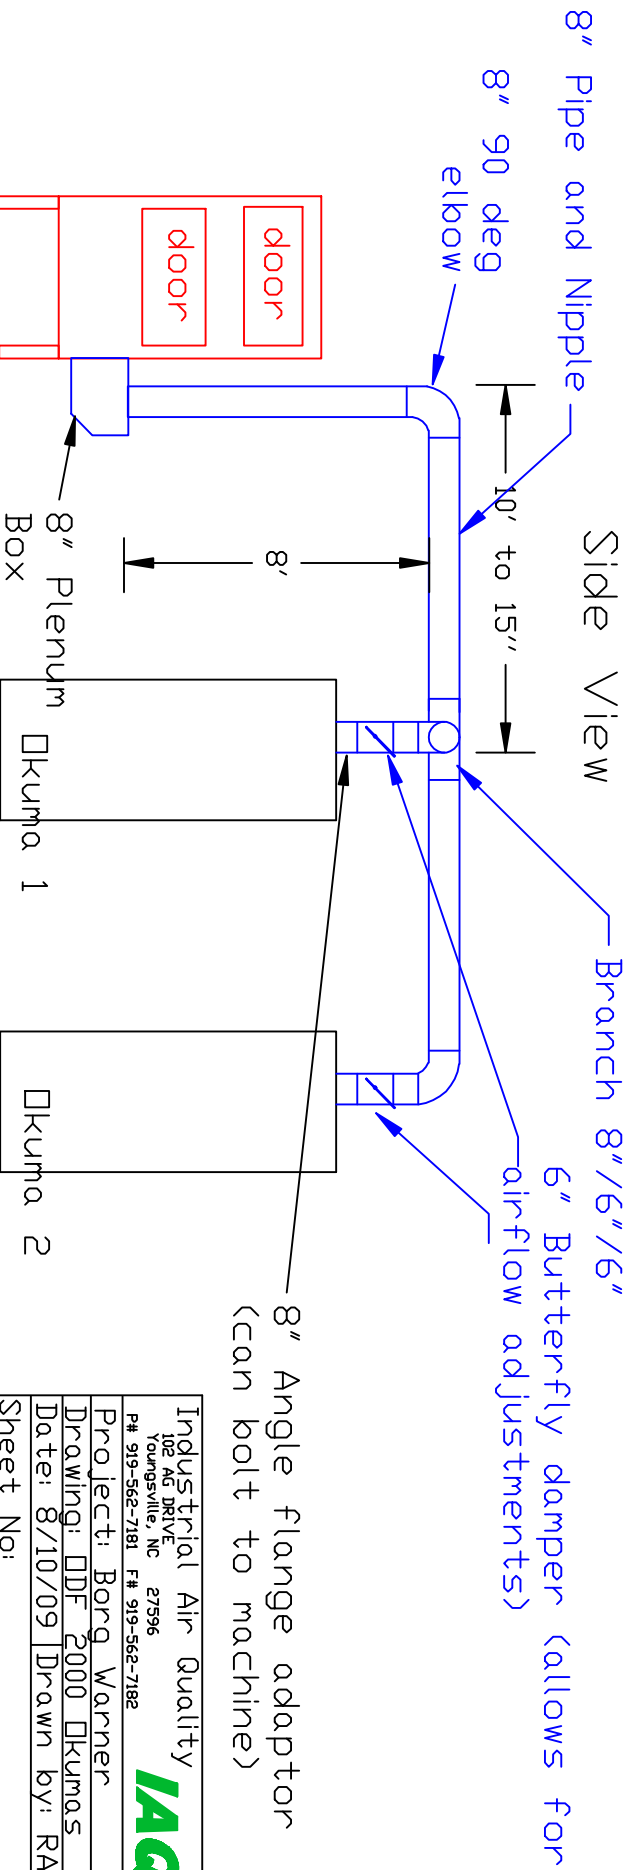

8" Angle flange adaptor
(can bolt to machine)

Industrial Air Quality	
102 RD DRIVE	27596
Youngsville, NC	
P# 919-562-7181	F# 919-562-7182
Project: Borg Warner	
Drawing: DDF 2000 DKuma	
Date: 8/10/09 Drawn by: RAV	
Sheet No:	

