



# Ductwork layout for DDF 2000

Plan View

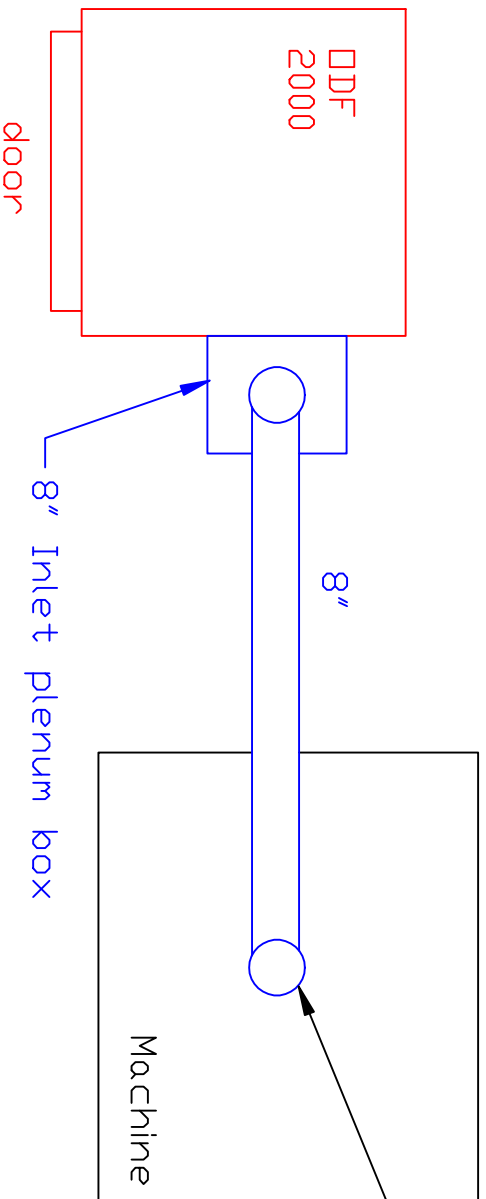

IAQ to cut 8" diameter hole in top of machine

Side View

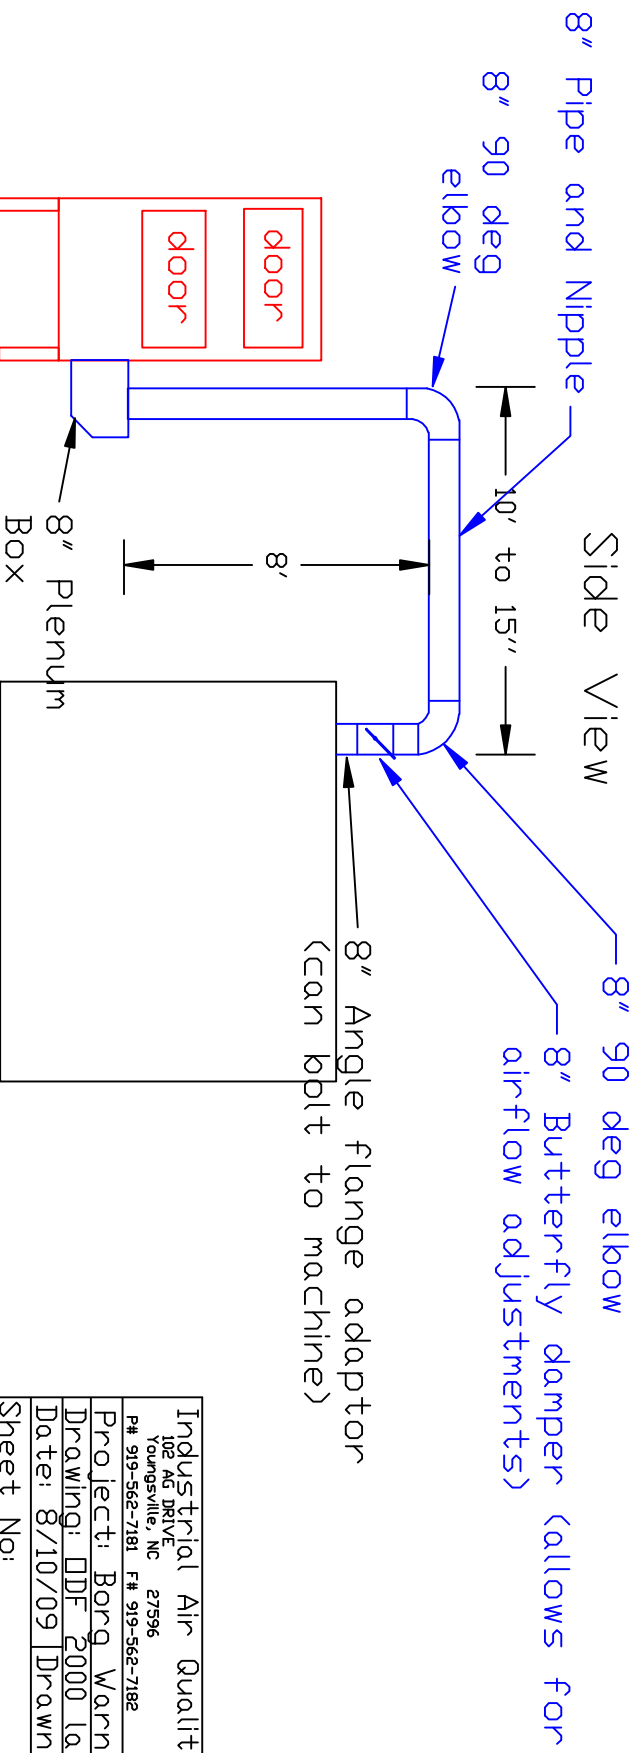

Industrial Air Quality  
 102 AG DRIVE  
 Youngsville, NC 27596  
 P# 919-562-7181 F# 919-562-7182  
 Project: Borg Warner  
 Drawing: DDF 2000 layout  
 Date: 8/10/09 | Drawn by: RAV  
 Sheet No:

