


# Absolent Ductwork Layout

## Plan View

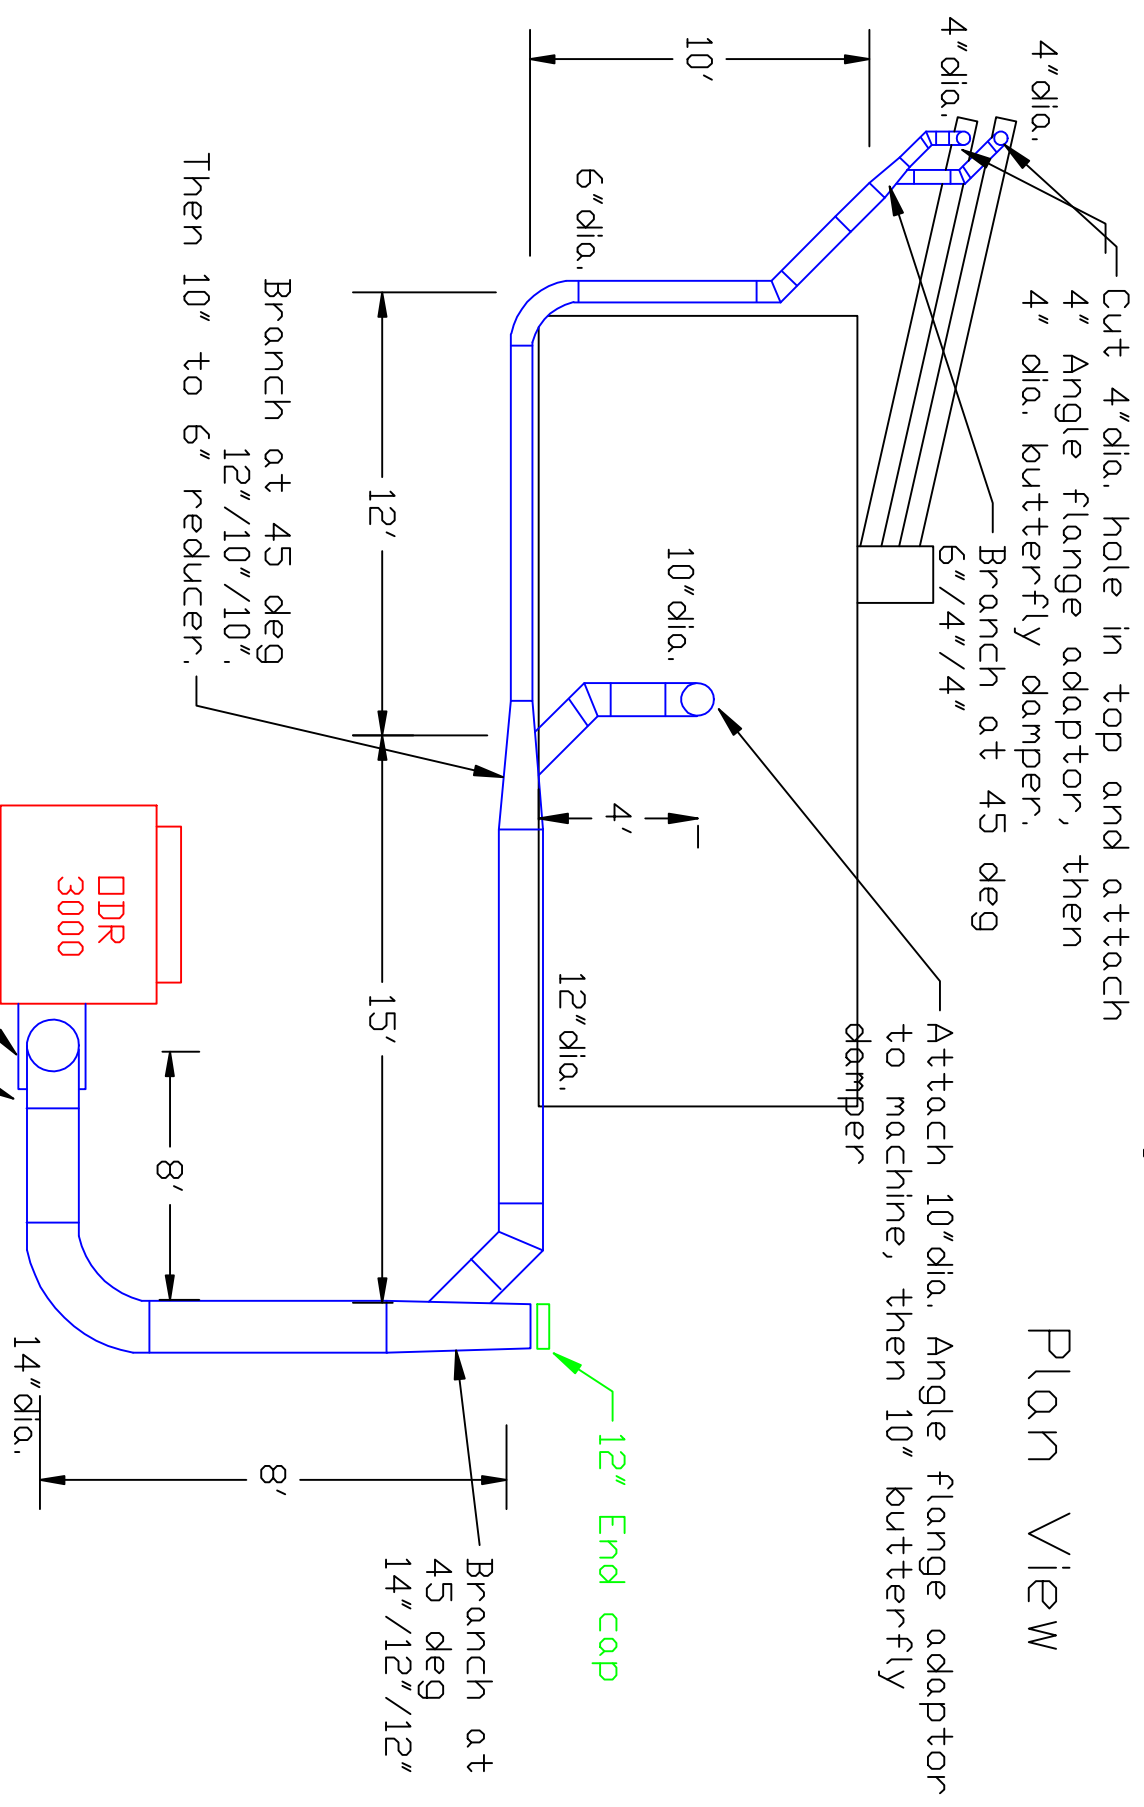

Note: Vertical run about 12' then 90 deg over.

Avani Environmental 95 Cypress Drive 27596 Youngsville, NC # 919-570-2862 F# 919-570-2863	
Project: Charter Automotive Drawing: Ductwork layout Date: 10/31/11   Drawn by: RAV Sheet No:	