



# Charter Automotive Duct Layout

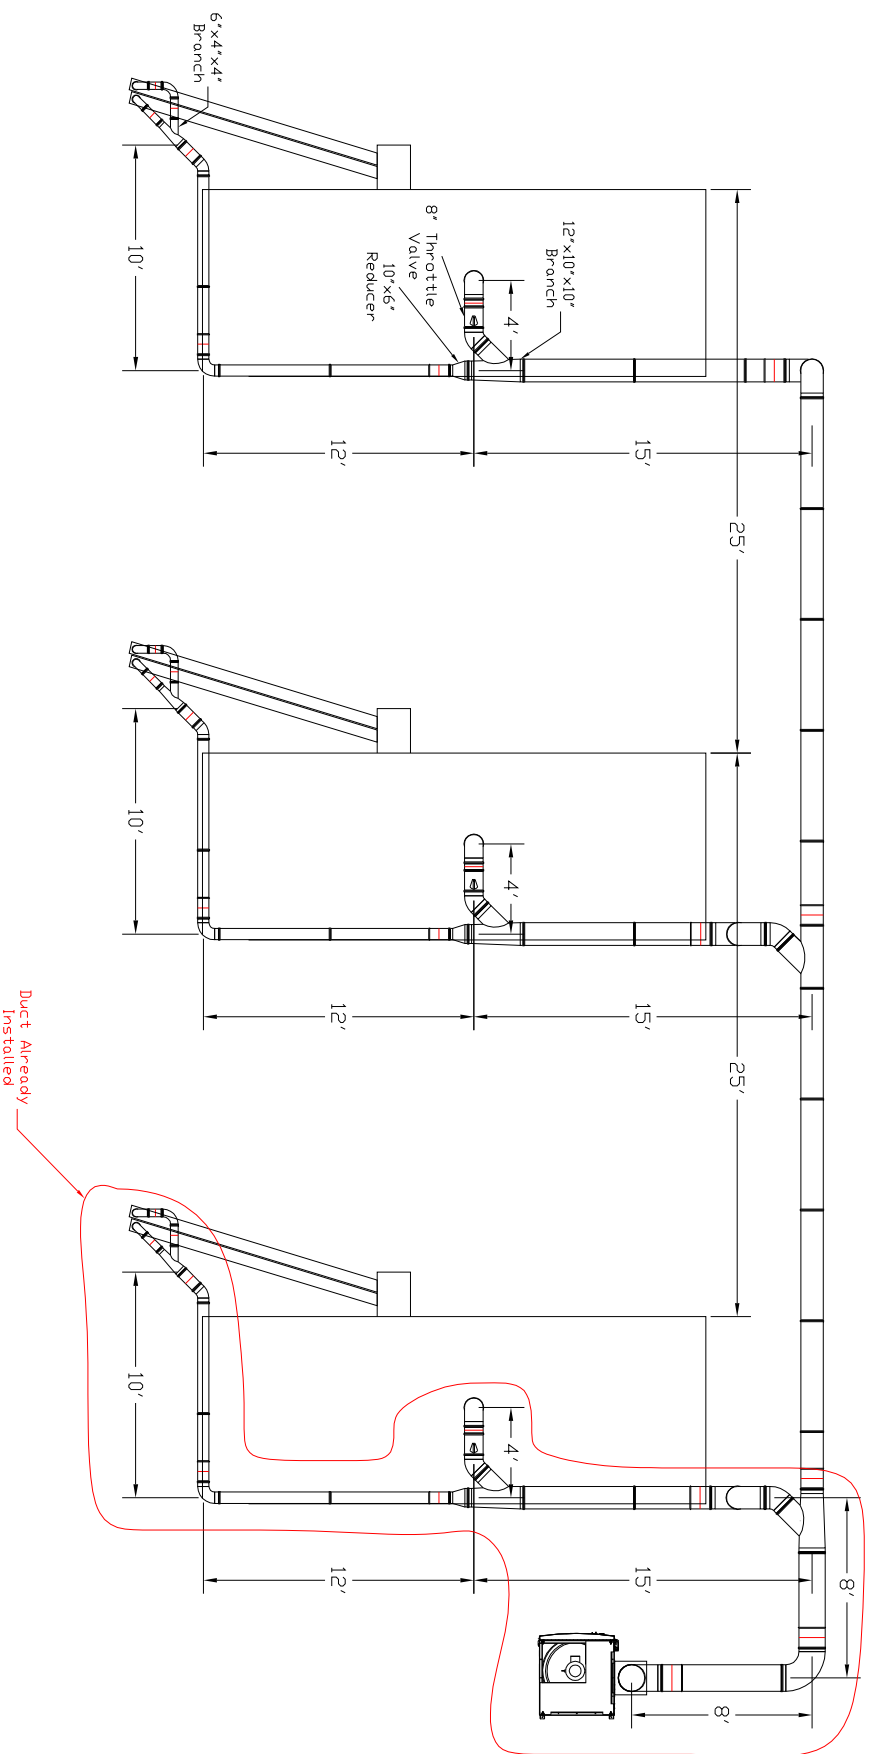

Plan View

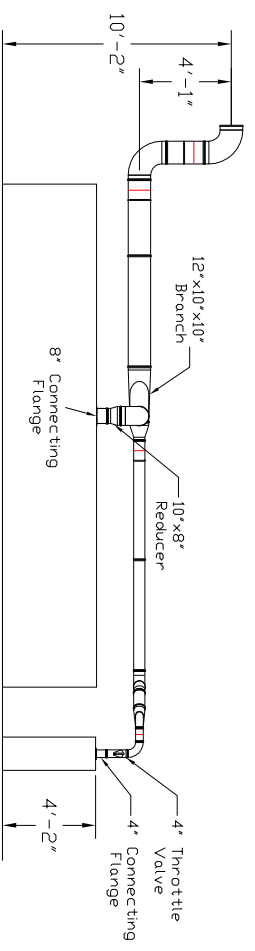

Elevation View

Avani Environmental 95 Cypress Drive Youngsville, NC 27596 P# 919-570-2862 F# 919-570-2863	
Project: Charter Automotive	
Drawing: Ductwork layout	
Date: 11/14/13 Drawn by: MDT	
Sheet No:	