
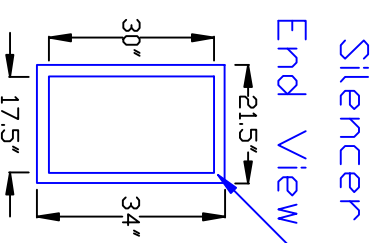


Absolent Ductwork Layout Side View

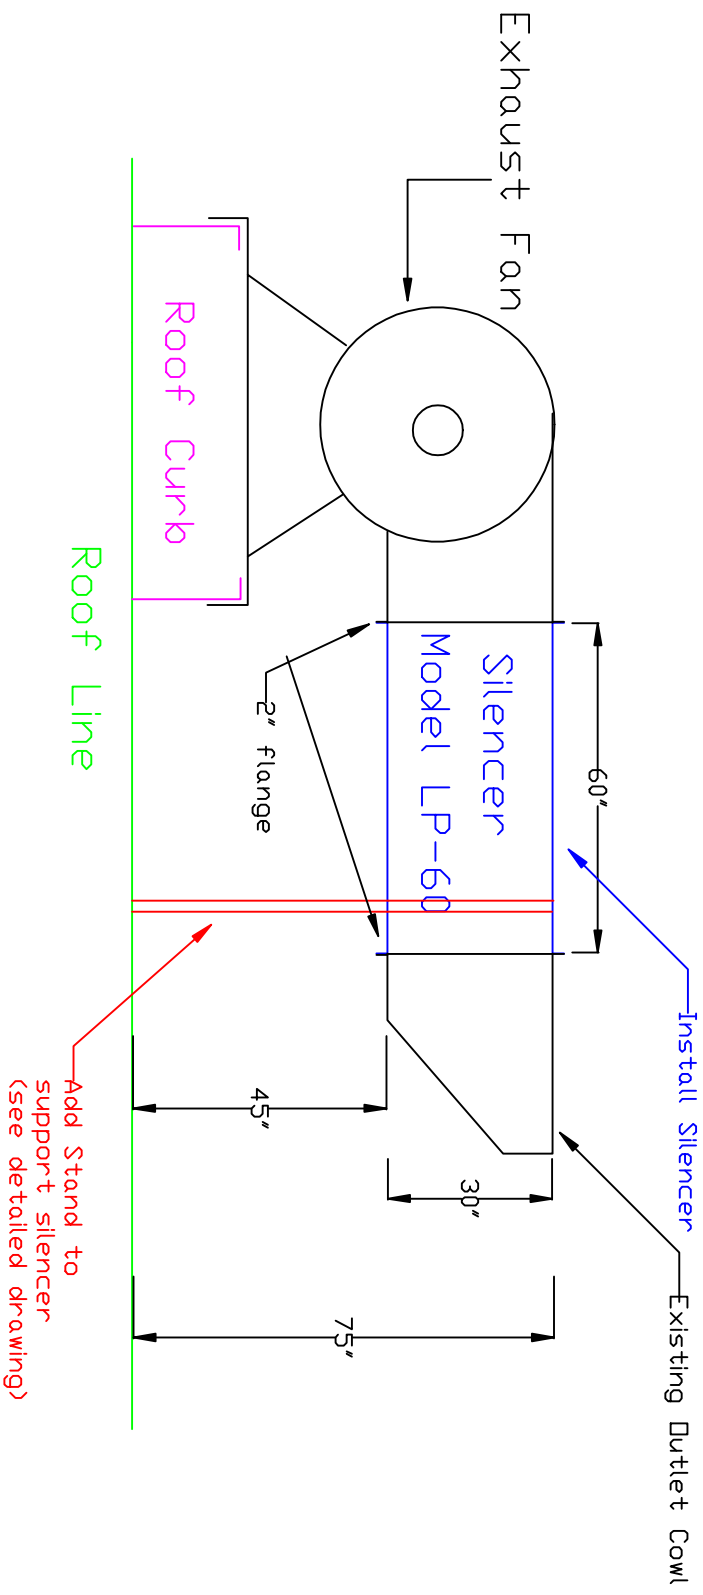

Avani Environmental Intl. Inc.
 95 Cypress Drive 27596
 Youngsville, NC
 # 919-570-2862 F# 919-570-2863
Avani
 Project: Coastal Carolina CC
 Drawing: Silencer & Stand
 Date: 05/8/12 | Drawn by: DDJ
 Sheet No: