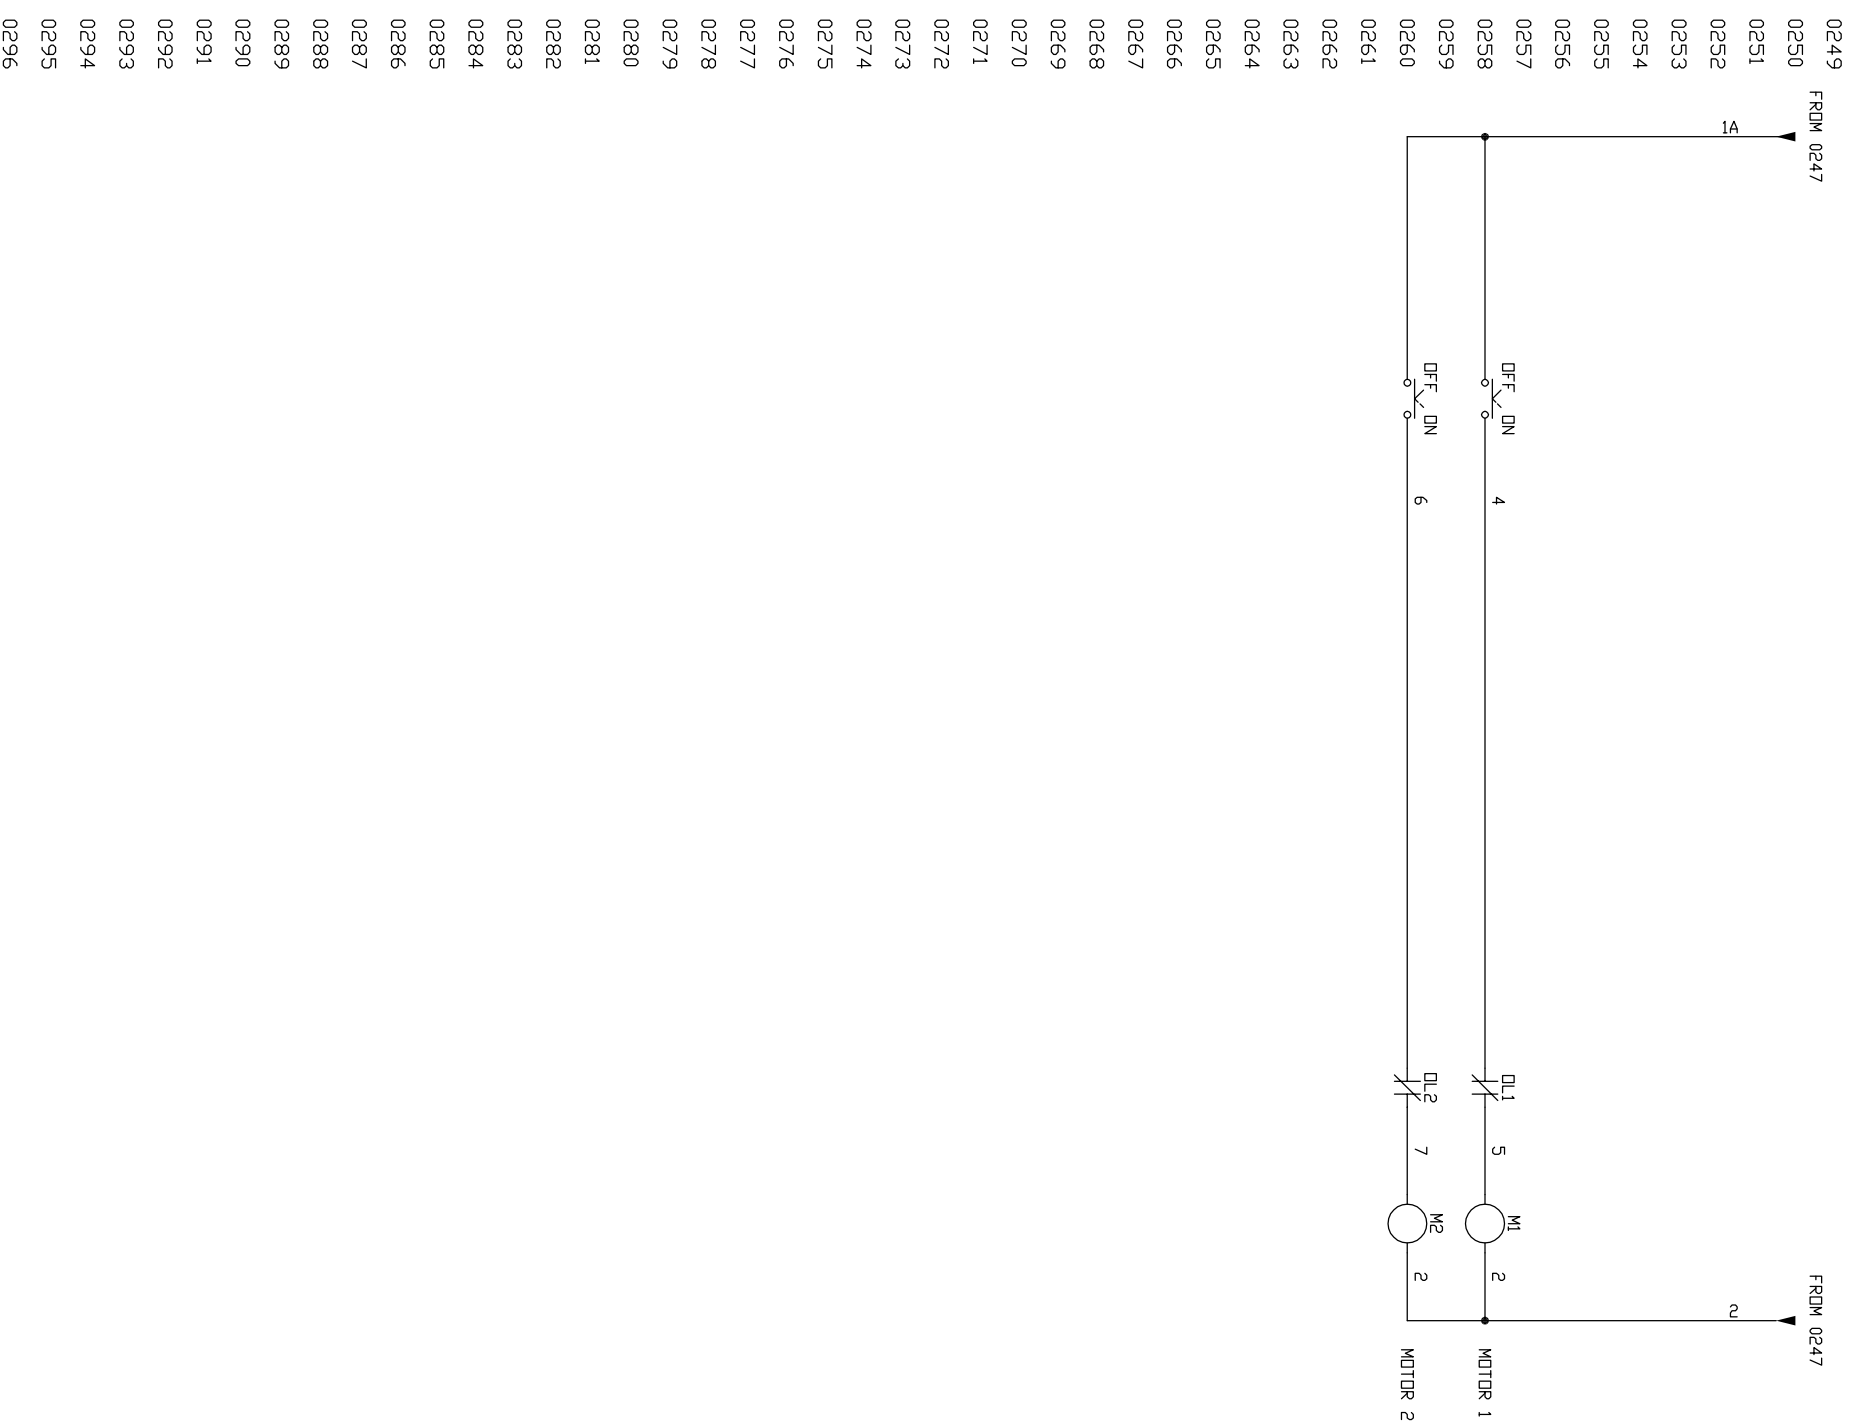


0201	460VAC, 3Ø, INPUT
0202	
0203	
0204	
0296	

REV.	DESCRIPTION	BY	CHK'D	APP'D	DATE

THIS DRAWING IS A PRIVATE AND CONFIDENTIAL COMMUNICATION AND THE PROPERTY OF ESSCO, INCORPORATED. IT MUST NOT BE COPIED OR LENT WITHOUT CONSENT OF ESSCO, INC. AND MUST BE PROMPTLY RETURNED WITH TENDER AND/OR COMPLETION OF ORDER.

**ESSCO**  
ELECTRIC SERVICE & SALES, INC.

1800 Sullivan St., Greensboro, NC 27405	TITLE
Tel: (336) 275-5321 Fax: (336) 275-5325	10HP 460V 3 PHASE & 1/2HP 120V 1 PHASE
Web site: www.esscoinc.com	ELECTRICAL LAYOUT
DRAWN BY: RM	SCALE: NTS
CHECKED BY: RM	DRAWING NUMBER: 04260102
APPROVED BY:	
9/24/04	

REV. A	LAST WIRE 7
--------	-------------