



# Absolent Ductwork Layout Plan View

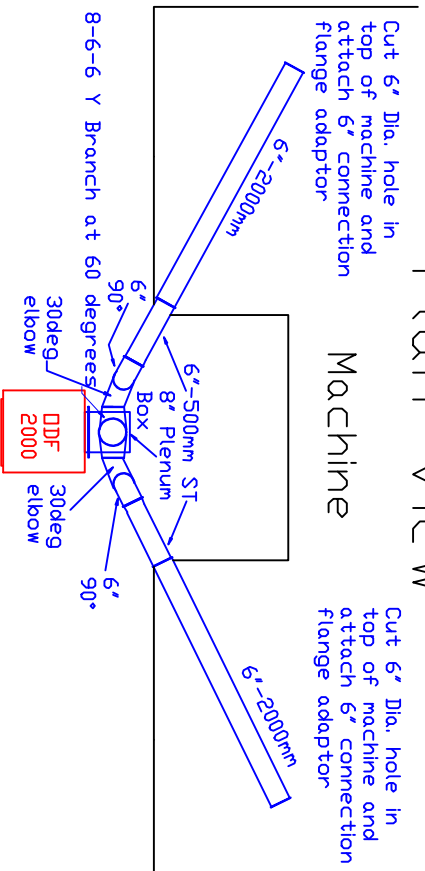

## Elevation View

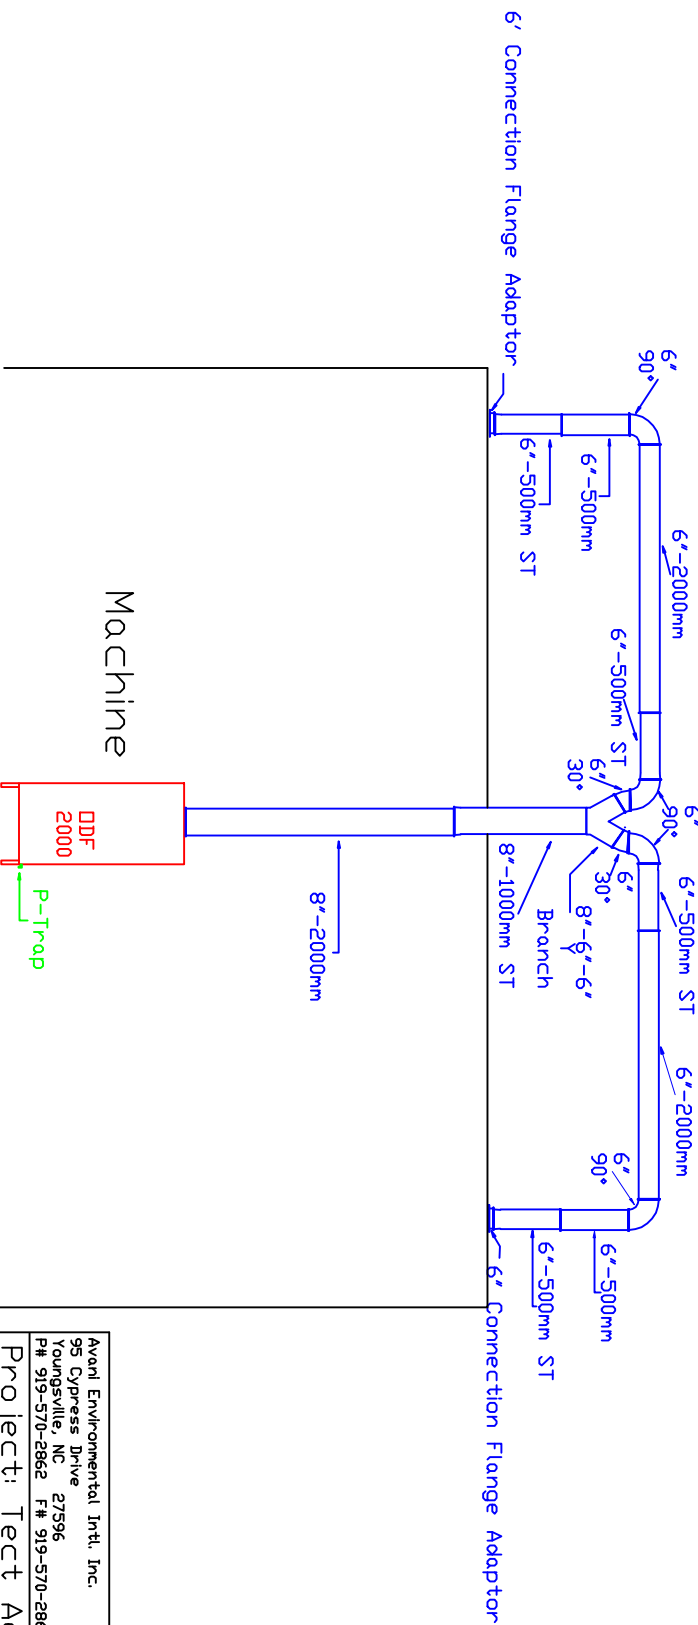

Avoni Environmental Intl. Inc.  
 95 Cypress Drive 27596  
 Youngsville, NC  
 # 919-570-2862 # 919-570-2863

**Avani**

Project: Tect Aero  
 Drawing: Duct Layout  
 Date: 3/24/12 | Drawn by: DOJ  
 Sheet No: