


Plan View of Ductwork Layout Balance Drawing Block Line - #2 - CNC Cell#2

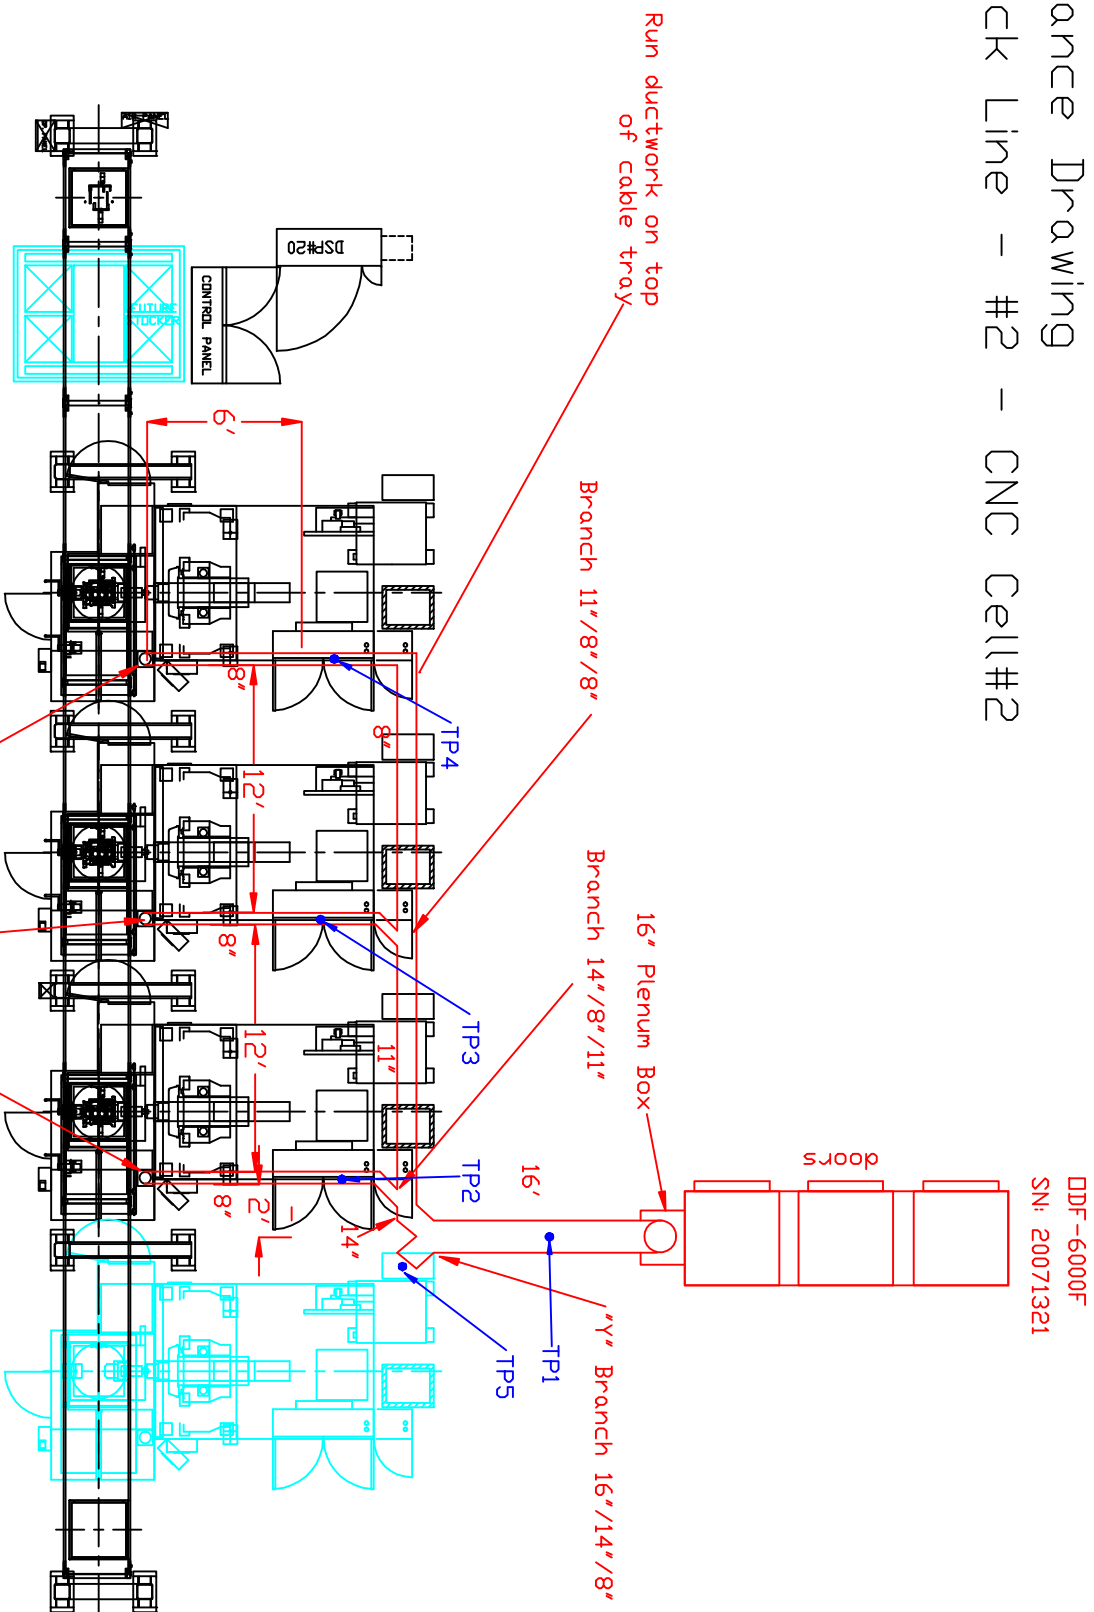

- Notes:
- A) Each drop will have a Butterfly damper for airflow adjusting.
 - B) Each drop will have a Bleed in valve to allow for balancing.
 - C) DDF 6000F has 3 - 3.5HP 460volt 3Phase motors. Full load amps are 4.6amps each.
 - D) Drain line! By Honda.

Industrial Air Quality
95 Cypress Drive 27596
Youngsville, NC
P# 919-562-7181 F# 919-562-7182



Project: Honda Canada-Balance
Drawing: Block #2 CNC Cell #2
Date: 09/10/08 Drawn by: W/B
Sheet No: 2 of 12 Rev: 0