


Plan View of Ductwork Layout Balance Drawing Head #5 Linebore

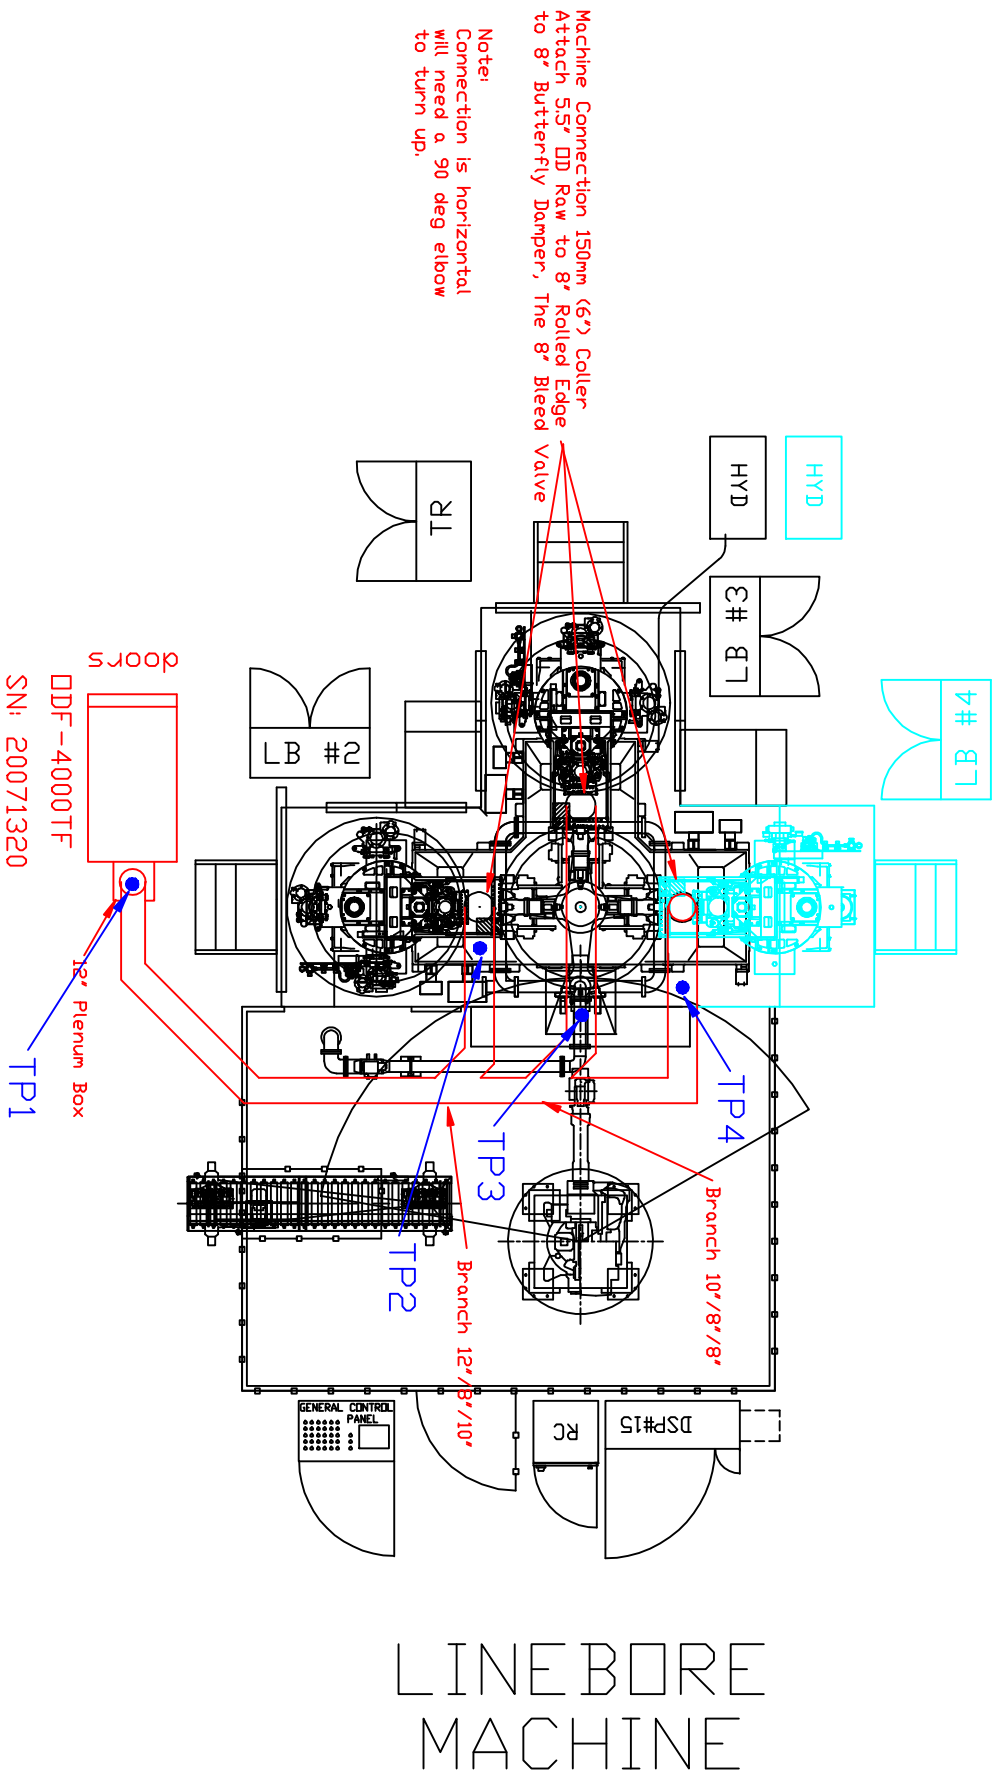

LINEBORE MACHINE

- Notes:
- A) Each drop will have a Butterfly damper for air-flow adjustment.
 - B) Each drop will have a Bleed in valve to allow for balancing.
 - C) DDF 4000TF has SHP 460volt 3Phase motor. Full load amps are 8.33amps.
 - D) Drain line: By Honda.

Industrial Air Quality
95 Cypress Drive 27596
Youngsville, NC # 919-562-7182

Project: Honda Canada-Balance
Drawing: Head #5 Linebore
Date: 09/10/08 Drawn by: W/B
Sheet No: 5 of 8 Rev: 0

