


Plan View of Ductwork Layout

Block Line - #4 - Coolant System #1

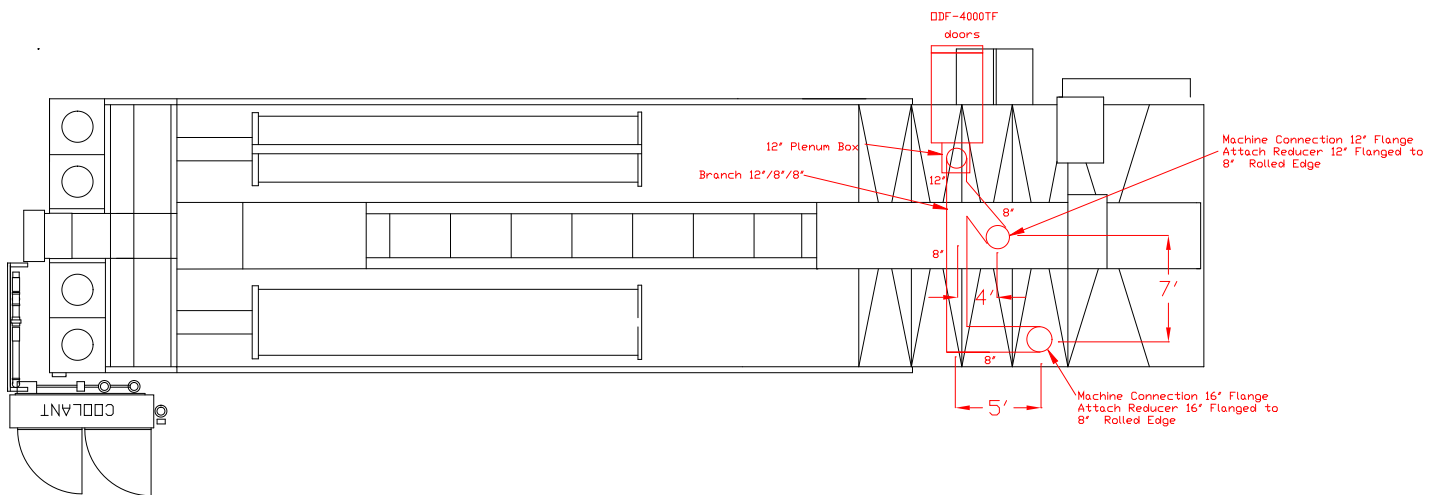

Notes:

- A) Each drop will have a Butterfly damper for airflow adjustment.
- B) Each drop will have a Bleed in valve to allow for balancing.
- C) DDF 4000TF has 5HP 460volt 3Phase motor. Full load amps are 8.33amps.
- D) Drain line: P-Trap made of $\frac{3}{4}$ " Galvanized with ball valve and unions. IAQ to provide. Honda to provide piping to sump.

Industrial Air Quality		IAQ
95 CYPRESS DRIVE Youngsville, NC 27596		
P# 919-562-7181 F# 919-562-7182		
Project: Honda Canada		
Drawing: Block#4 Coolant Sys#1		
Date: 03/27/08		Drawn by: WWB
Sheet No:		