


Plan View of Ductwork Layout Head #1 - CNC Cell 1 & 2

CNC CELL #1 CNC CELL #2

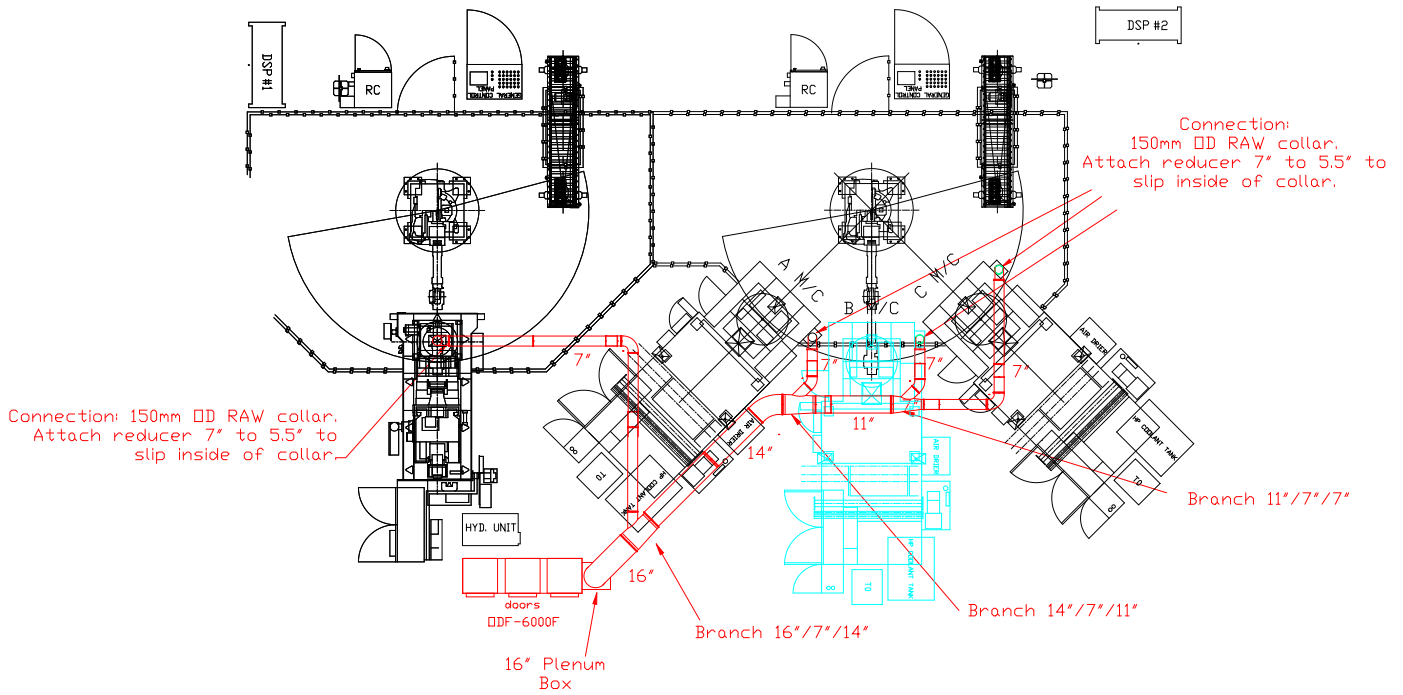

Notes:

- A) Each drop will have a Butterfly damper for airflow adjustment.
- B) Each drop will have a Bleed in valve to allow for balancing.
- C) ODF 6000F has 3 - 3.5HP 460volt 3Phase motors. Full load amps are 4.6 amps each.

D) Drain line: P-Trap made of $\frac{3}{4}$ " Galvanized with ball valve and unions. IAQ to provide. Honda to provide piping to sump.

Industrial Air Quality		IAQ
95 Cypress Dr. Youngsville, NC 27596		
P# 919-562-7181 F# 919-562-7182		
Project: Honda Canada		
Drawing: Head #1 CNC 1 & 2		
Date: 3/29/08	Drawn by: WWB	
Sheet No:		