


Ductwork Layout for DDR 2000 / Lab

Plan View

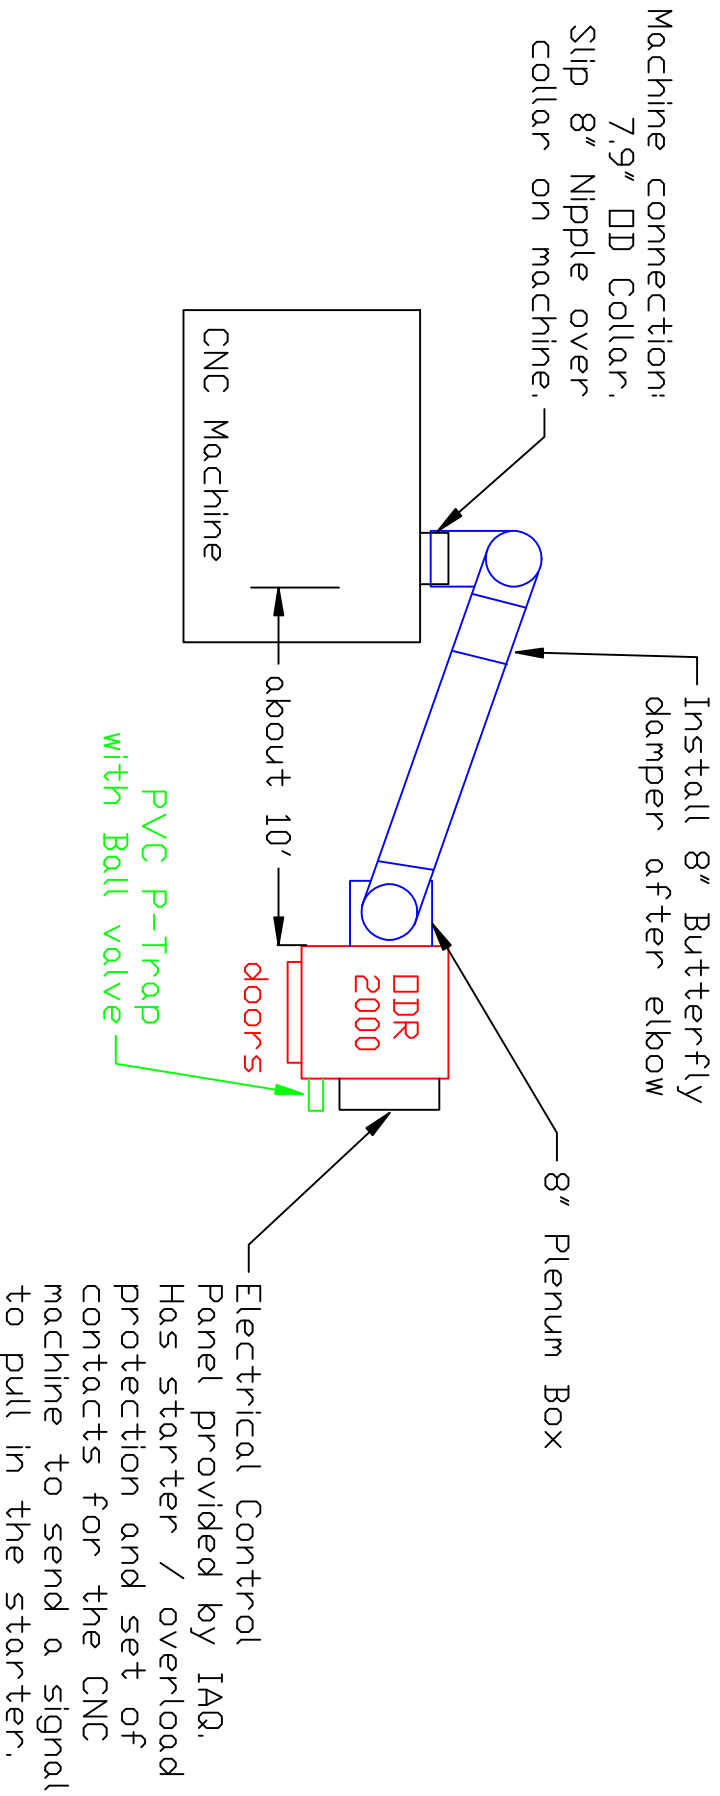

Note:
Run ductwork about 7'
to 8' off of floor.
Check with Steve to
confirm height.

Industrial Air Quality
102 AG DRIVE
Toungesville, NC 27596
PH # 919-562-7181 F# 919-562-7182
Project: Kennametals
Drawing: Ductwork layout
Date: 12/10/09 Drawn by: RAV
Sheet No:

