


Absolent Ductwork Layout

Side View

Jacob Tubing

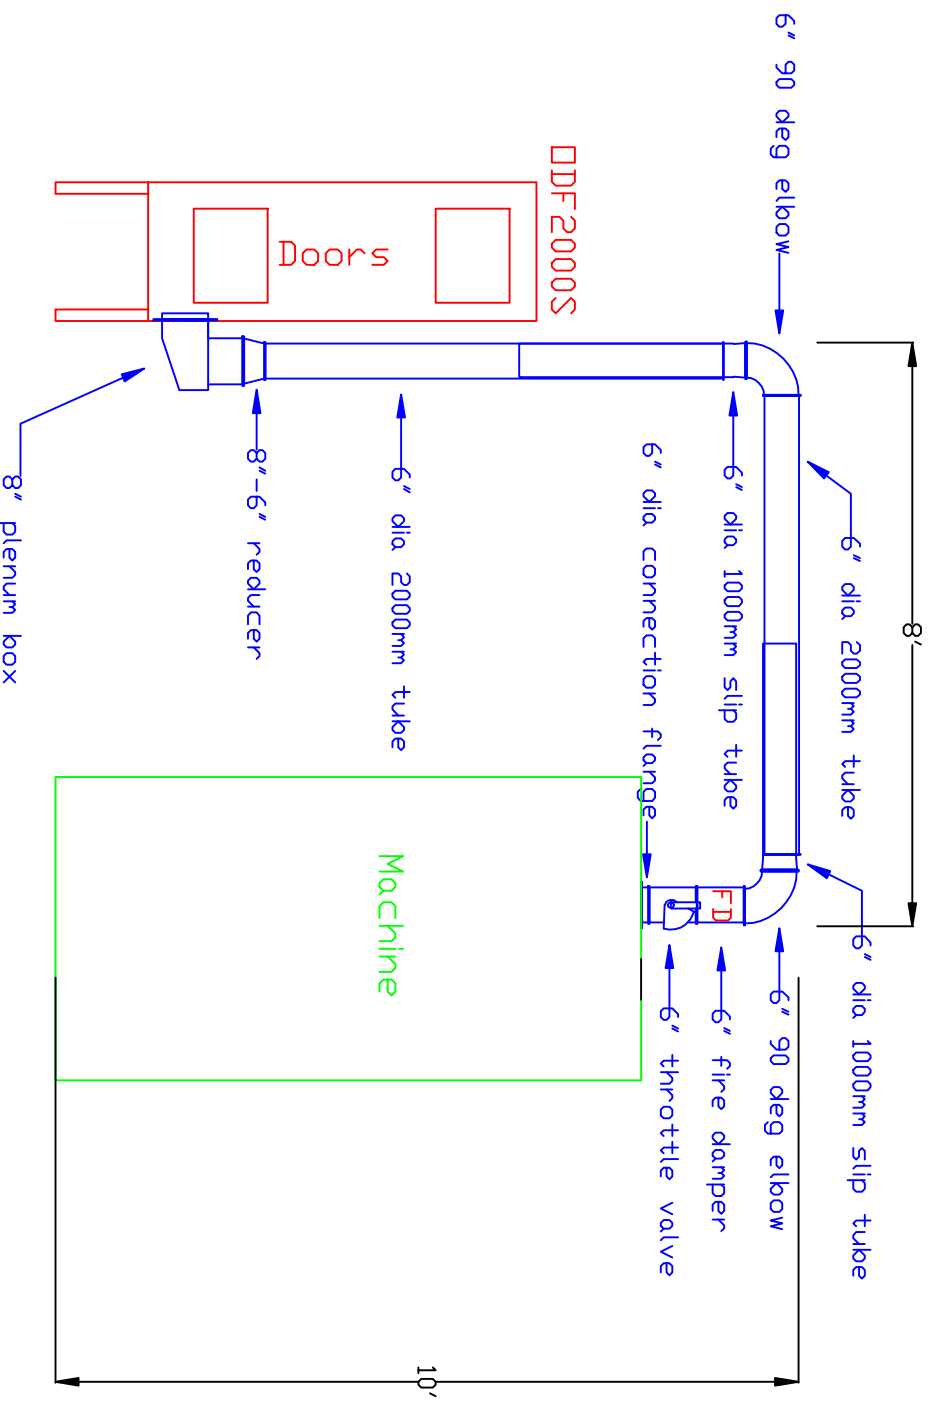

Avani Environmental Intl. Inc.

95 Cypress Drive 27596

Youngsville, NC

Phone: 919-570-2862 Fax: 919-570-2863



Project: Kenco Aerospace

Drawing: DDF2000S

Date: 5-09-12 Drawn by: DDJ

Sheet No: