


Ductwork Layout for Absolent Plan View

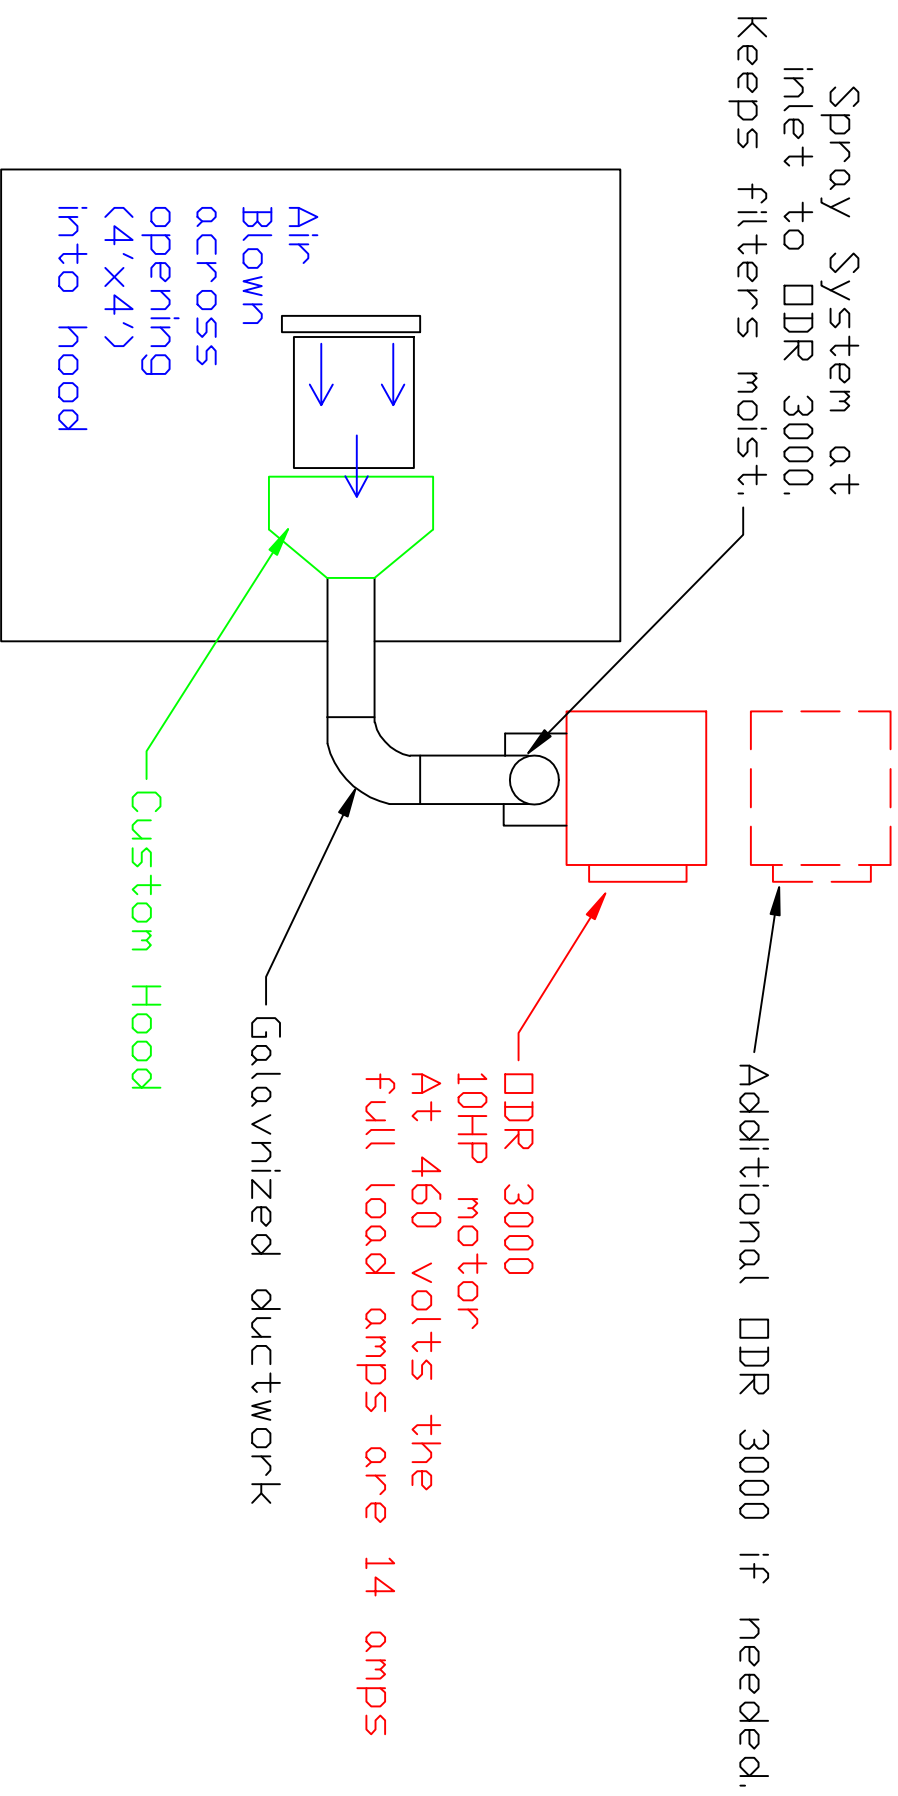

Avanti Environmental 95 Cypress Drive 27596 Raleighville, NC Ph: 919-570-2862 F# 919-570-2863	
Project:	Drop Forge
Drawing:	Ductwork Layout
Date:	12/19/11
Drawn by:	RAV
Sheet No:	