


Ductwork Layout for Heat Treat Elevation View

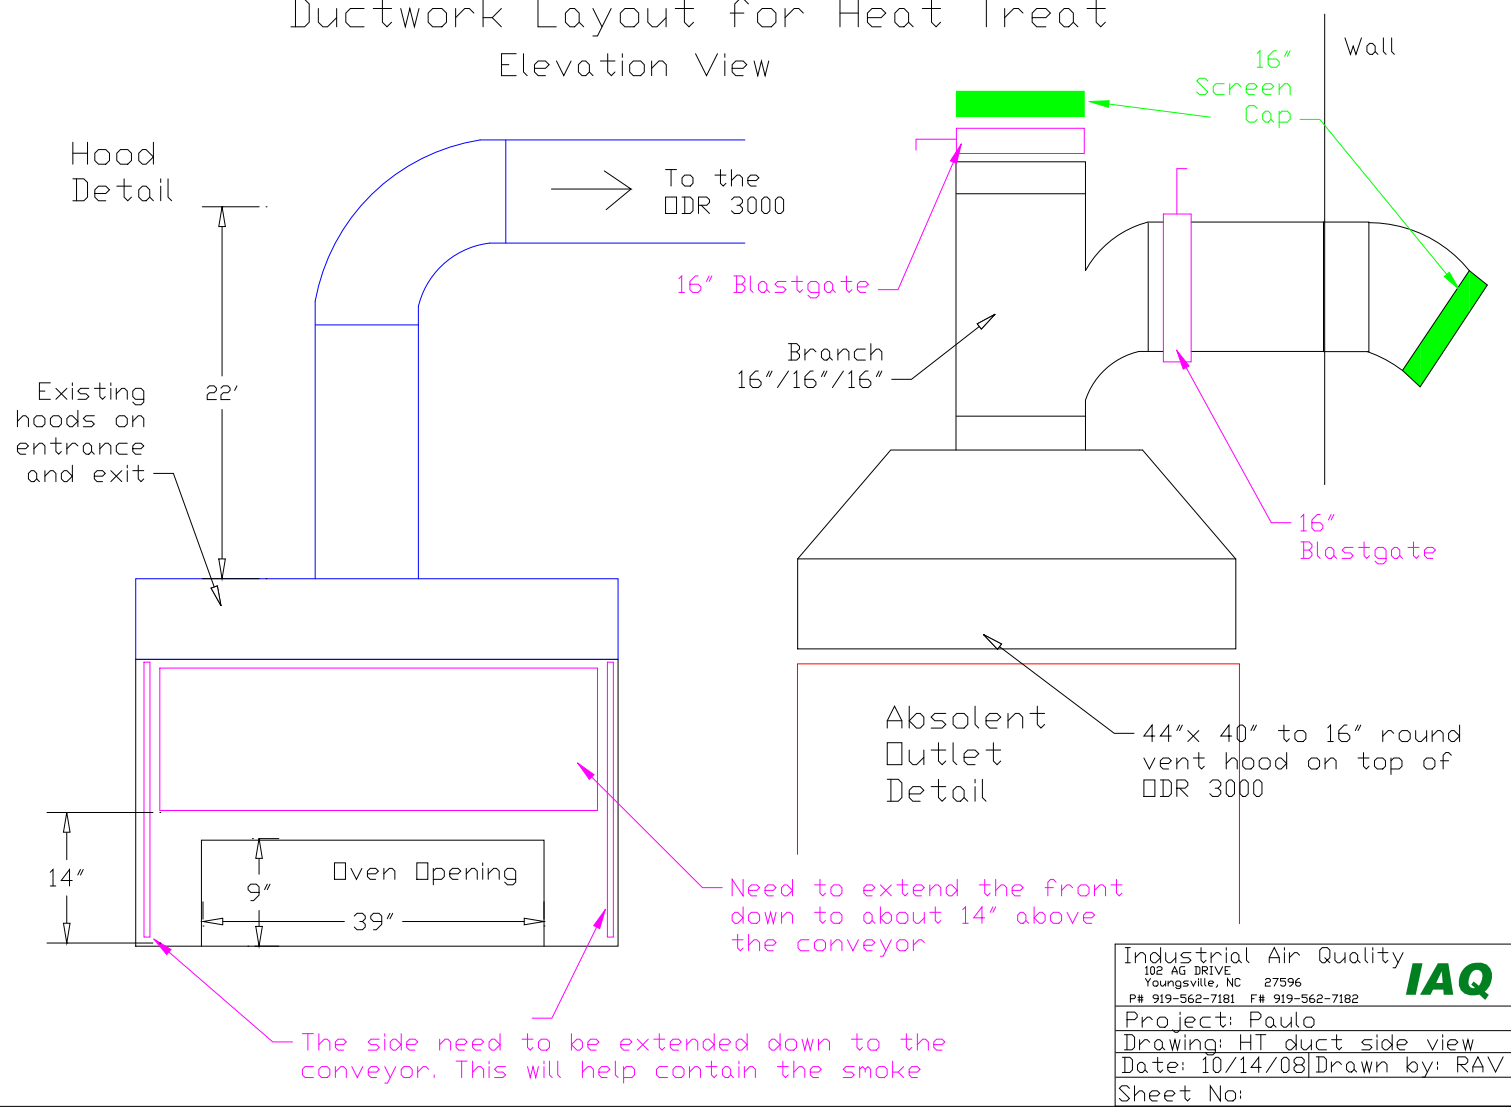

Industrial Air Quality		IAQ
102 AG DRIVE Youngsville, NC 27596		
P# 919-562-7181 F# 919-562-7182		
Project: Paulo		
Drawing: HT duct side view		
Date: 10/14/08		Drawn by: RAV
Sheet No:		