


Absolent Ductwork Layout for the Dkuma and 403

Plan View

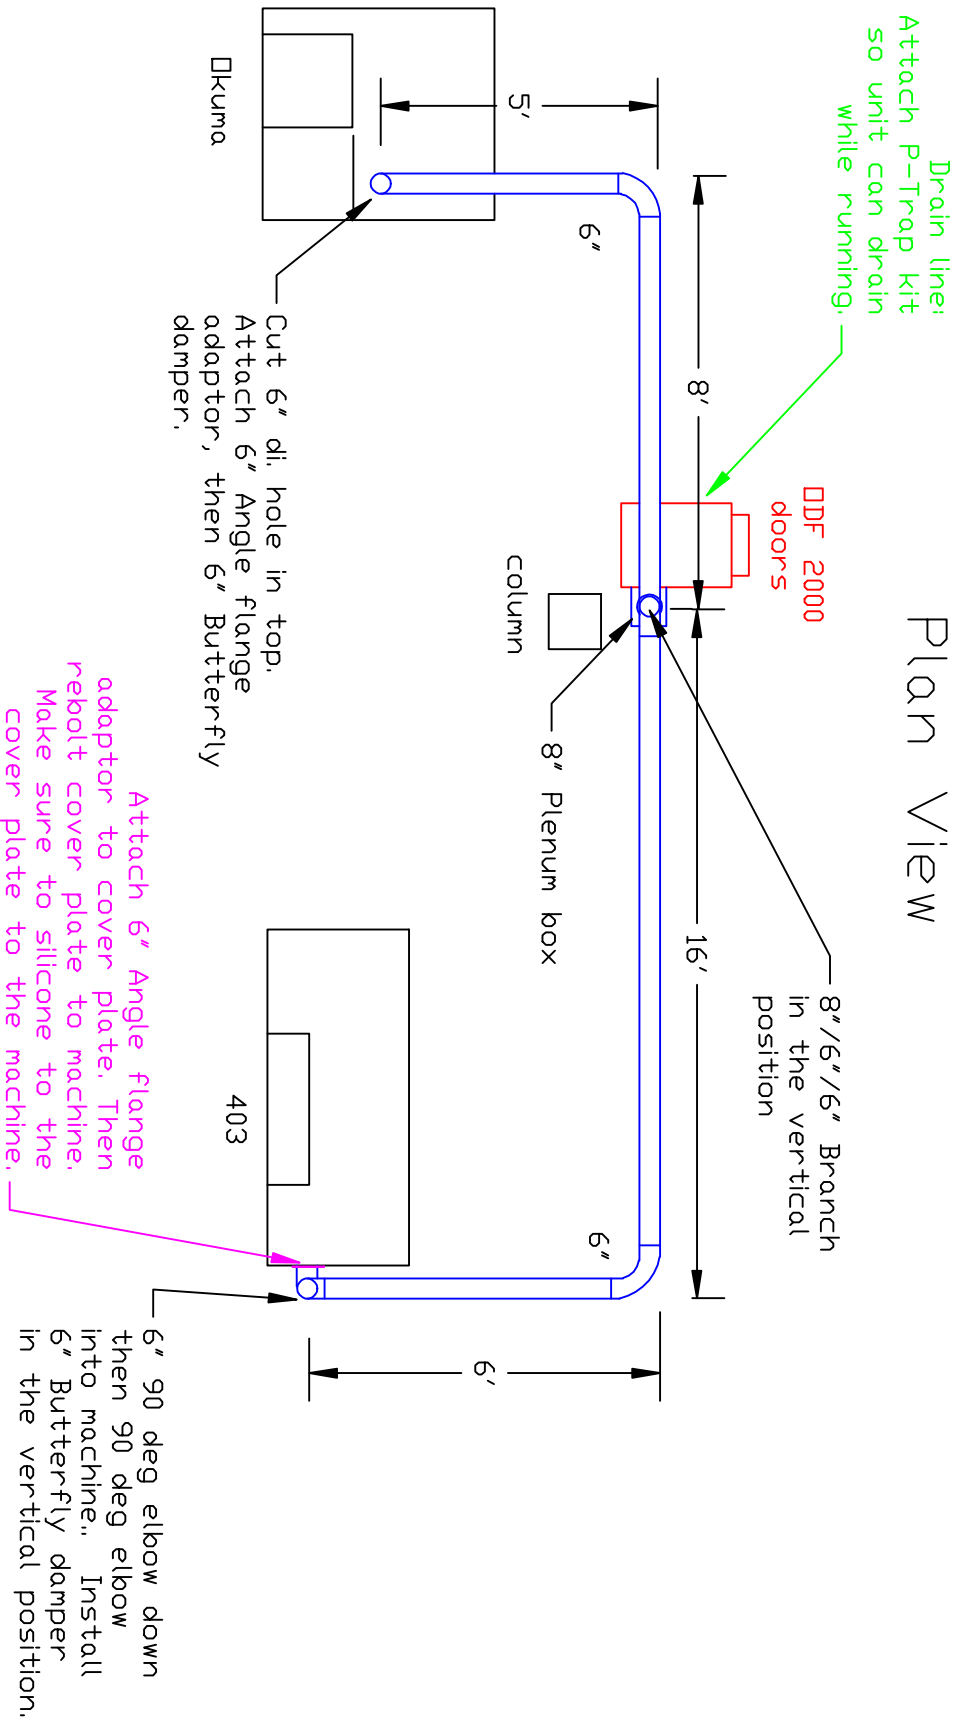

Avanti Environmental 95 Cypress Drive 27596 Raleighville, NC P# 919-570-2862 F# 919-570-2863	Avani
Project: RBC Bearings	
Drawing: Dkuma duct layout	
Date: 12/13/10 Drawn by: RAV	
Sheet No:	