


# Booth Collector Ductwork layout

## Plan View

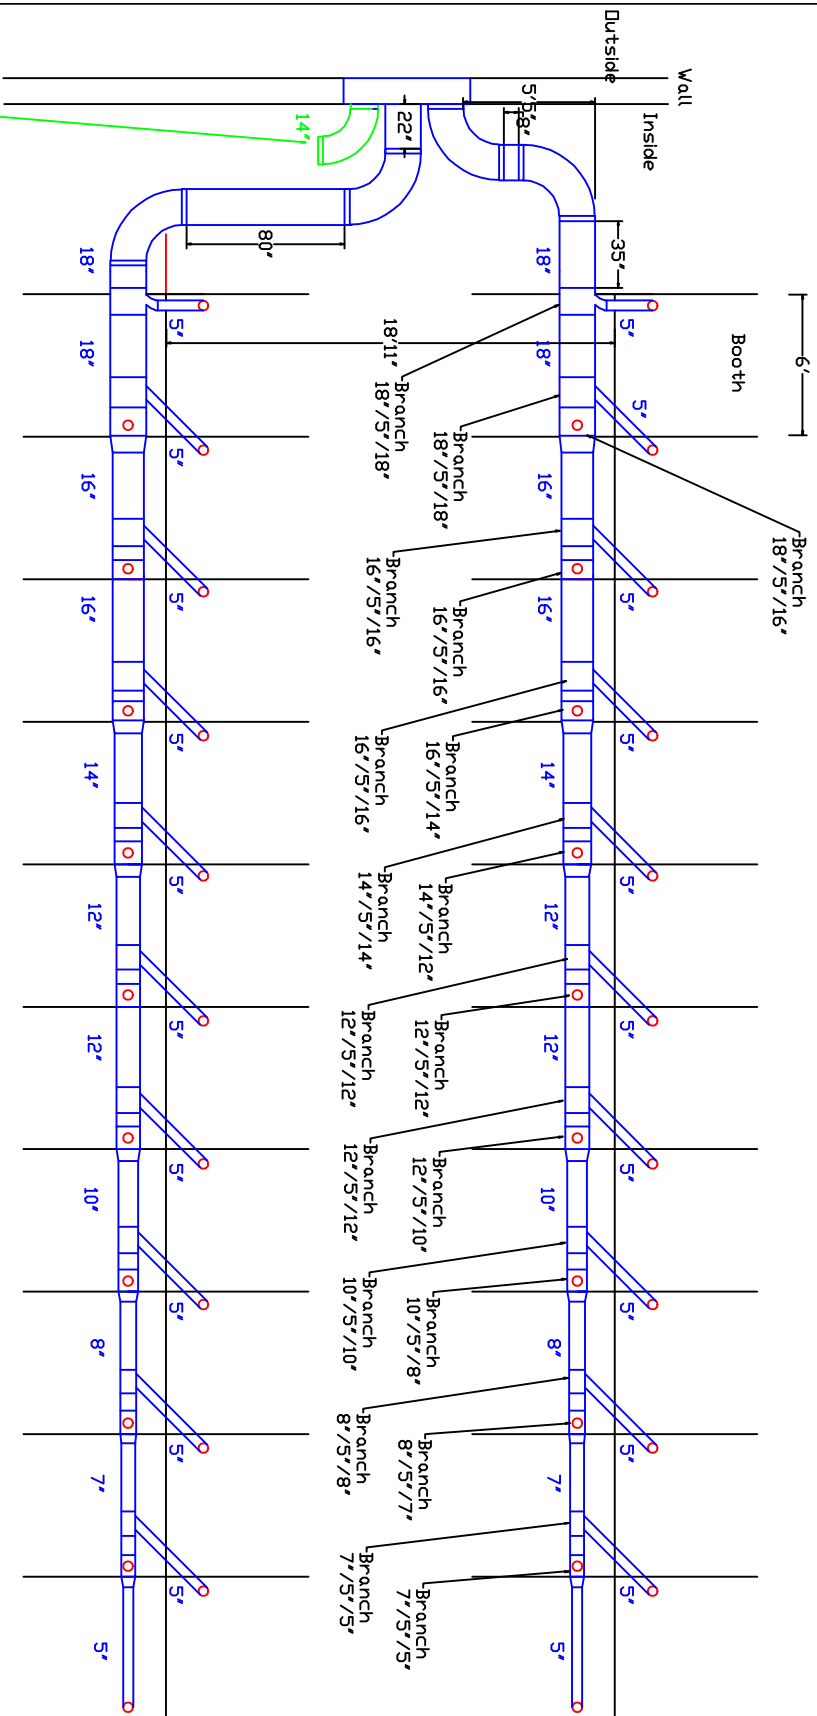

Cap off 14" diameter line for future use.

- Notes:
- A) All booths will have an Dskar fume arm 5" diameter by 7' reach. Fume arms to be mounted in right corner of each booth.
  - B) 14" diameter line will be capped off for future use

Industrial Air Quality
102 AG DRIVE
Youngsville, NC 27596
P# 919-562-7181 F# 919-562-7182
Project: Greenville Tech
Drawing: Booth duct layout
Date: 10/16/09 Drawn by: RAV
Sheet No:

