


KENNOTE LEGEND:

- (KN-1) EXISTING CONC. DBL. TEES AND LIGHTS TO REMAIN
- (KN-2) OPEN TO STRUCTURE
- (KN-3) NEW 2X2 ACI CEILING
- (KN-4) NEW MTL SOFFIT CEILING



CEILING LEGEND:

- 2'-0" x 2'-0" ACI. SYSTEM
- 1'-0" x 4'-0" FLUORESCENT FIXTURE REFER TO ELECTRICAL DRAWINGS
- 2'-0" x 2'-0" FLUORESCENT FIXTURE REFER TO ELECTRICAL DRAWINGS
- SMOKE DETECTOR (CEILING MOUNTED)
- EXHAUST AIR GRILLE


P.O. BOX 6287  
GREENVILLE, SC 29606  
103 NORTH MAIN STREET  
SUITE 200  
GREENVILLE, SC 29601  
(864) 682-1800  
FAX (864) 623-9400  
project@enwright.com  
www.enwright.com

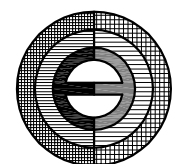

ENWRIGHT ASSOCIATES, INC.

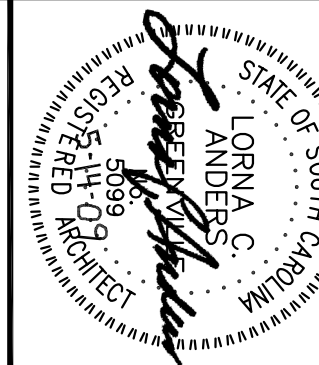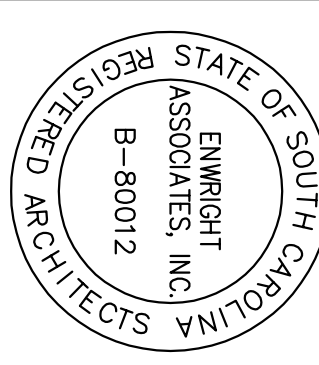



GREENVILLE TECH  
College That Works  
BARTON CAMPUS  
INDUSTRIAL COMPLEX RENOVATION  
STATE PROJECT NO: H59-9997-JM

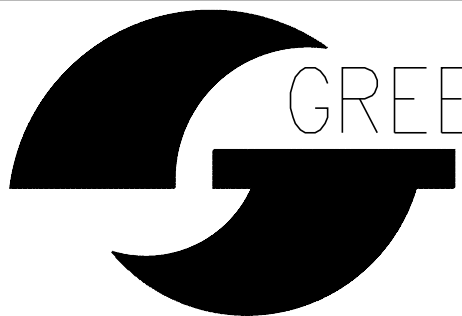

NO.	DATE	REVISION
JOB NO.	09GTECWELDING	DATE 6/15/09
DRAWN BY	JD	

REFLECTED CEILING PLAN

COMPLEX KEY PLAN

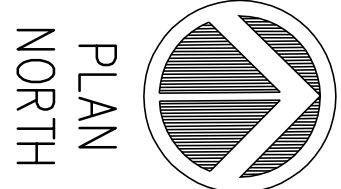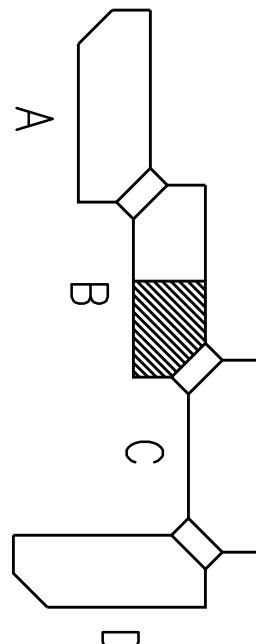

A1-2

NOTE:  
EXISTING VOICE AND DATA LINES ARE TO REMAIN  
CONTRACTOR IS TO IDENTIFY AND CLEARLY MARK  
RUNS THAT ARE TO BE PROTECTED DURING  
CONSTRUCTION.

REFLECTED CEILING PLAN

3/16" = 1'-0"

A1  
A1-2

