


# Absolent Ductwork Layout Side View

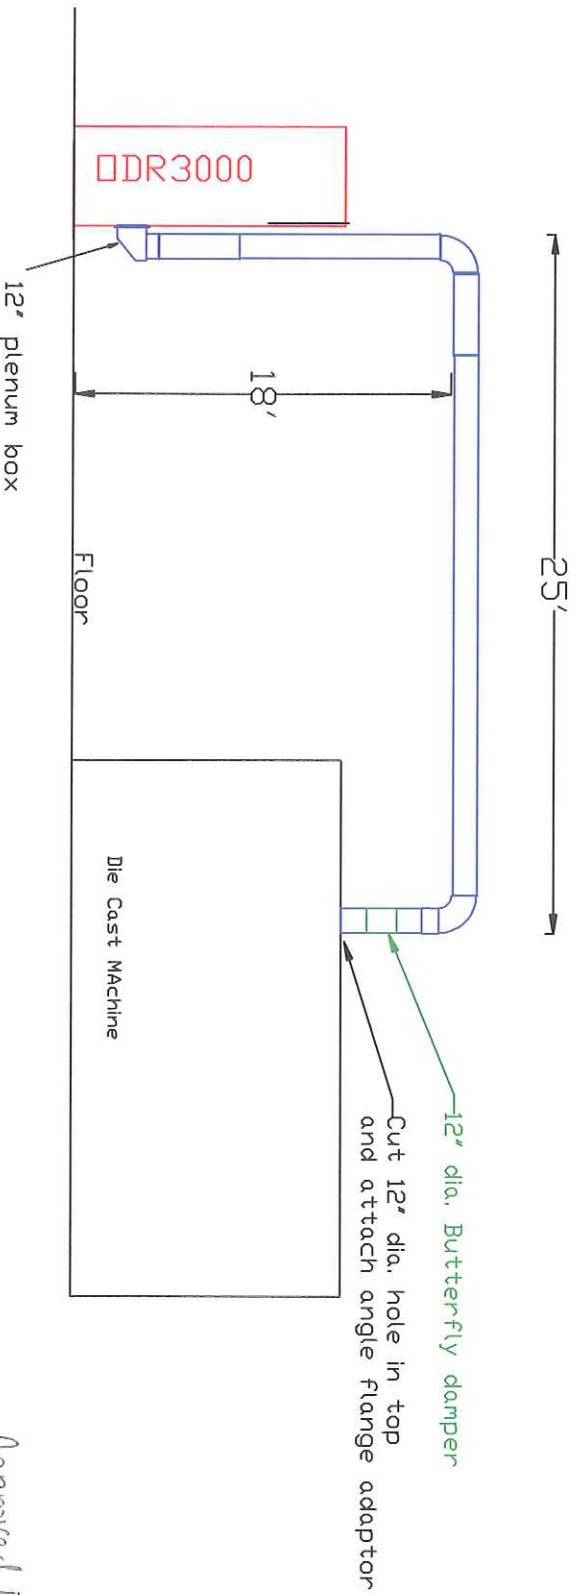

Notes:  
 A) DDR 3000 has 10 HP motor. At 460 volts full load amps are 14.5

Approved By:



Avani Environmental Intl. Inc.	
95 Cypress Drive	27396
Youngsville, NC	
Ph: 919-570-2862	F#: 919-570-2863
Project: THK Rhythm	
Drawing: Ductwork layout	
Date: 6-7-12	Drawn by: RAV
Sheet No:	

