


Aksolent Ductwork Layout

Side View

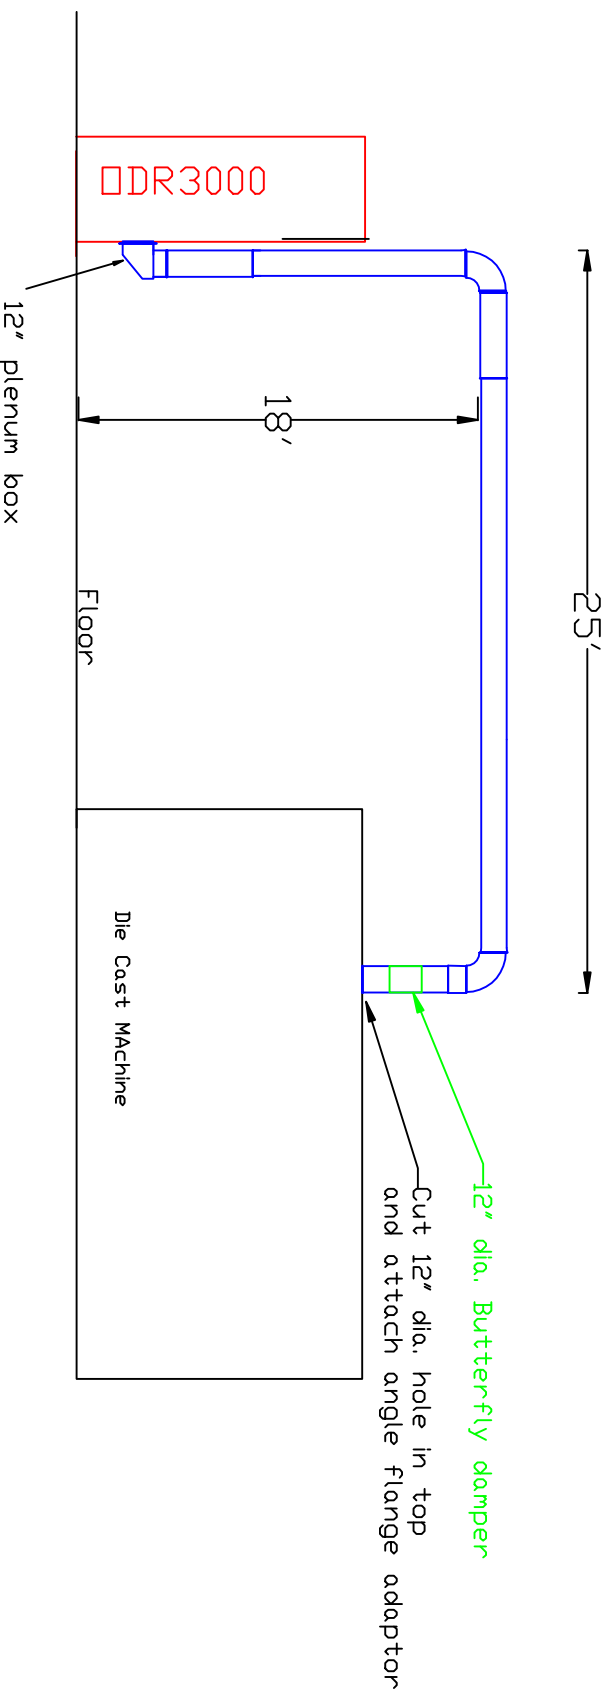

Notes:
A) DDR 3000 has 10 HP motor. At 460 volts full load amps are 14.5

Avani Environmental Intl. Inc.
95 Cypress Drive 27596
Youngsville, NC
P# 919-570-2862 F# 919-570-2863

Avani

Project: THK Rhythm

Drawing: Ductwork layout

Date: 6-7-12 Drawn by:RAV

Sheet No: