


Ductwork Layout For Department #40 Plan View

Note: For Ductwork connection to
MUG Grinders see: "MUG Grinder Connection
Detail" Drawing

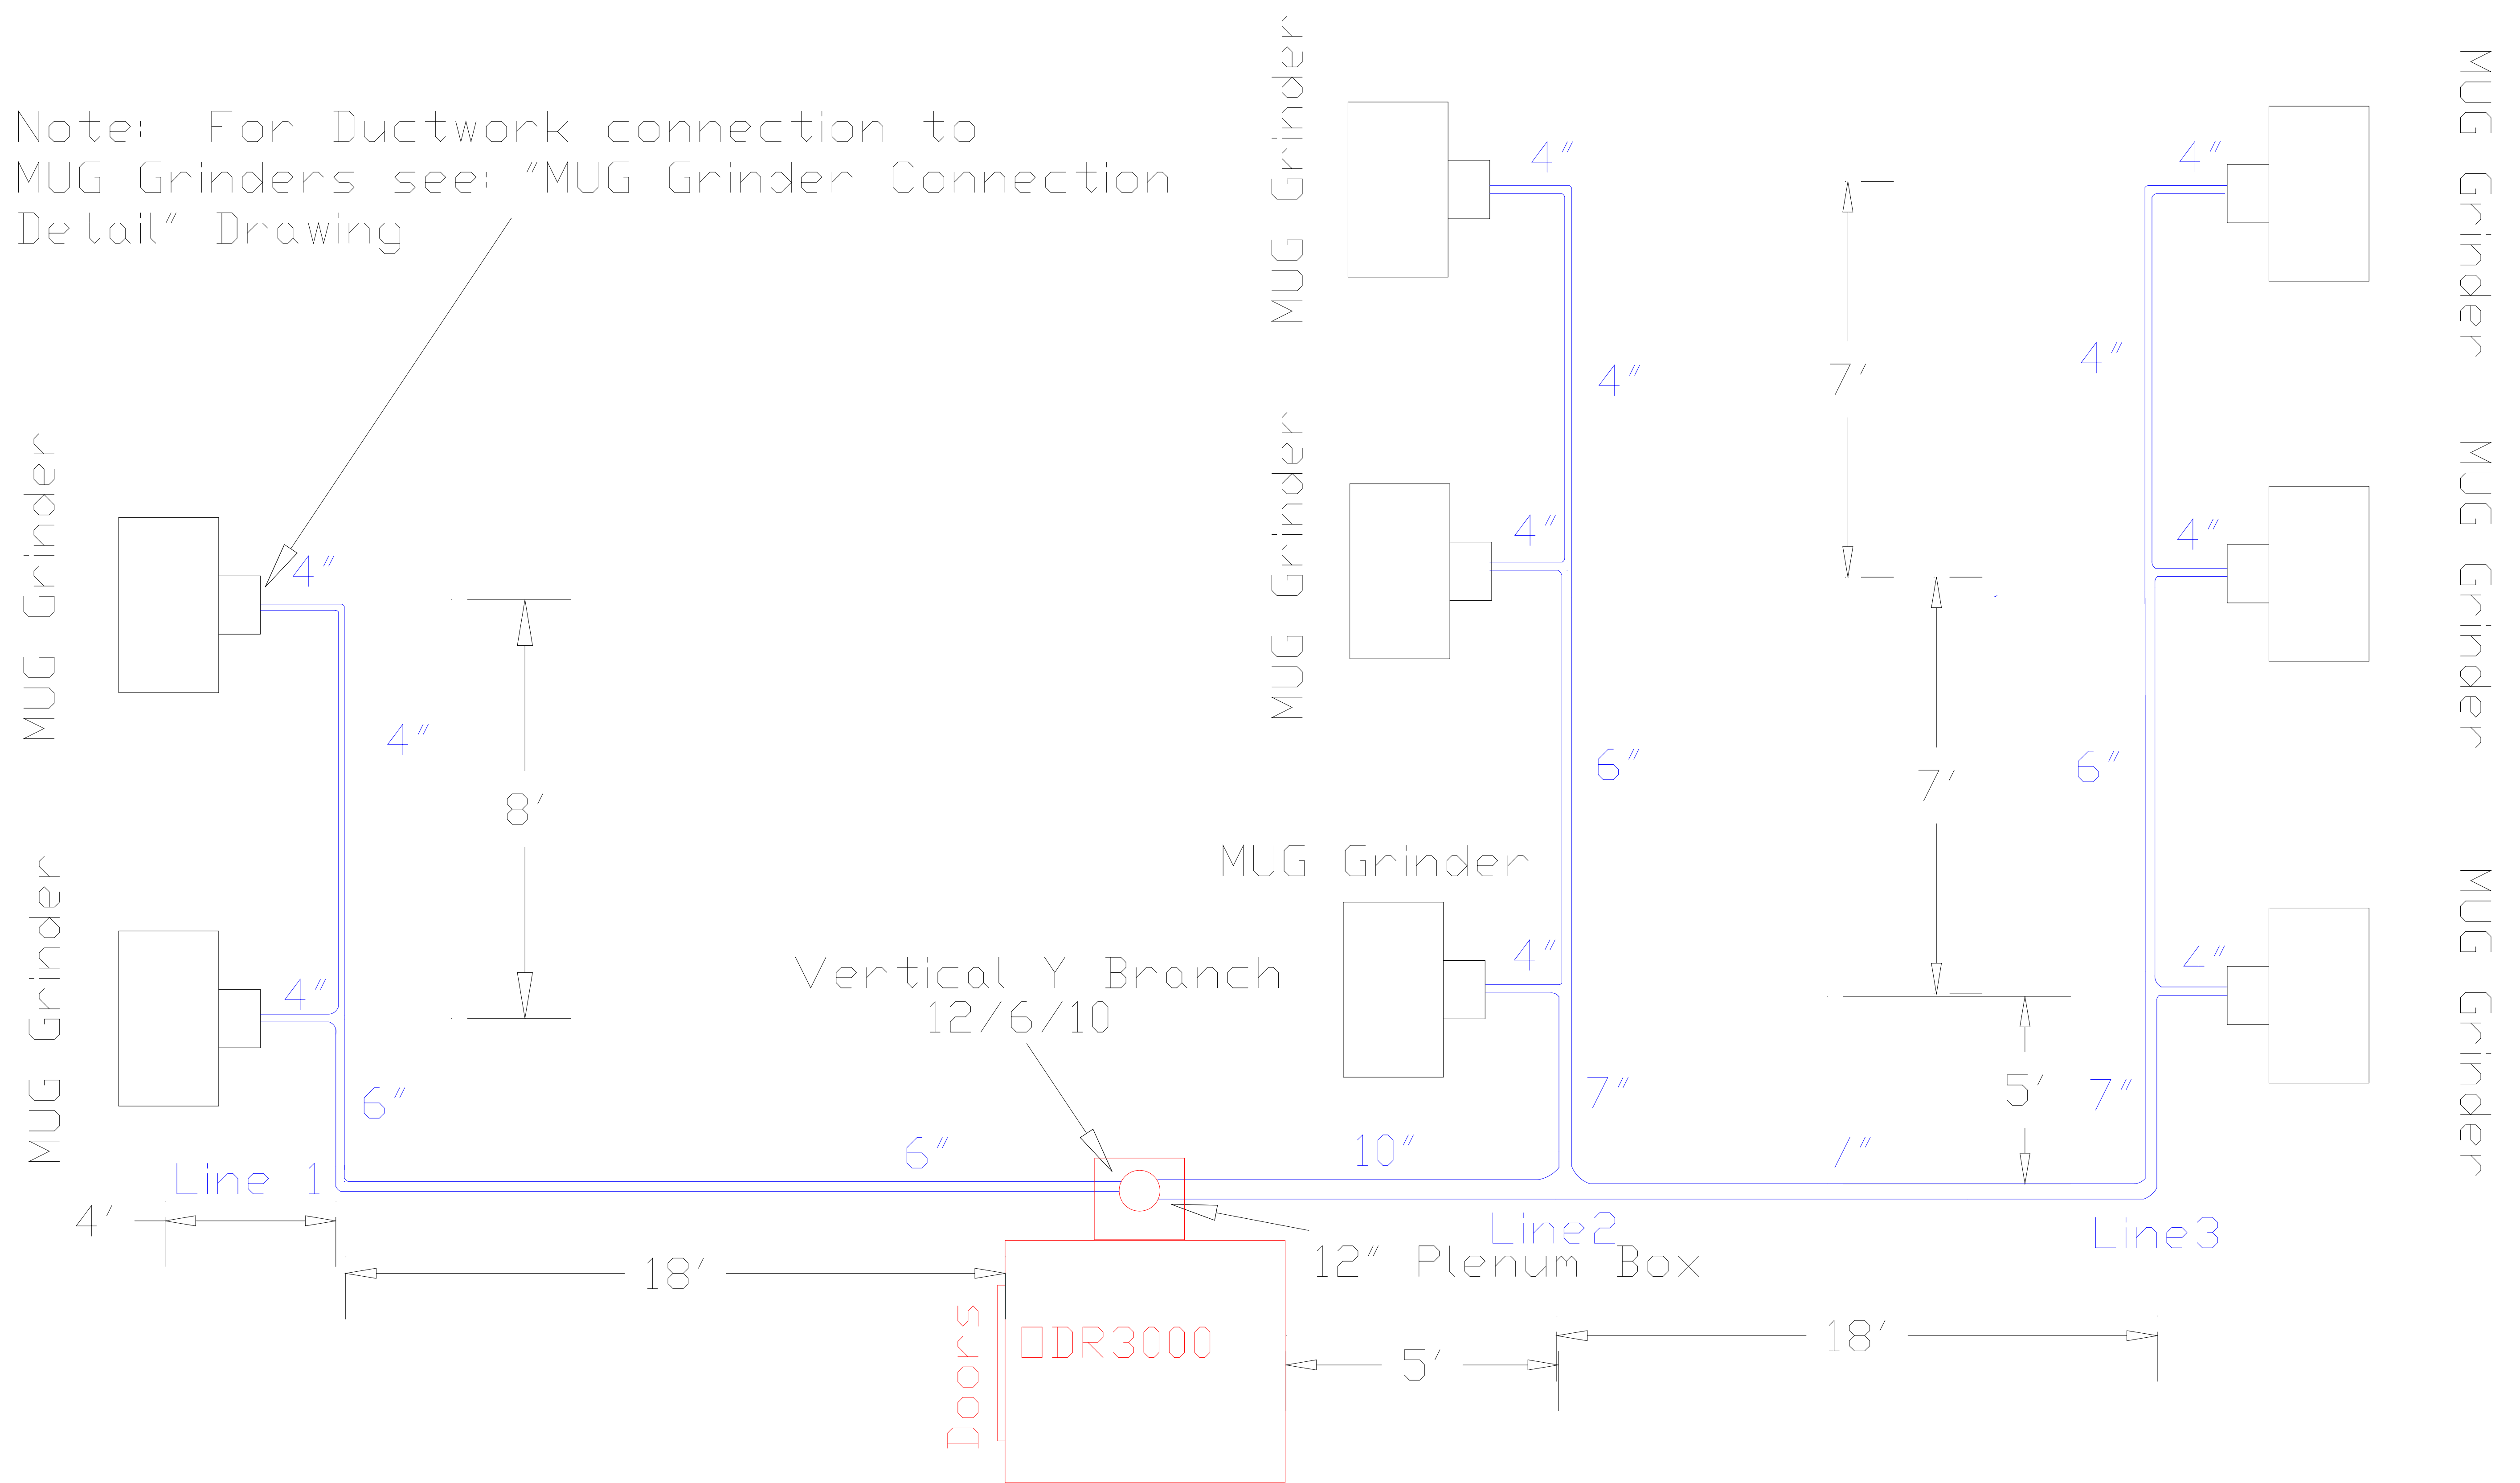

Notes:

- 1) 10HP Motor at 480 volts -3 phase. Full load amps are 14
- 2) Absolent will sit on a 14" stand
- 3) Blast gates at each drop for air flow adjustment
- 4) Ductwork will use existing stands
- 5) Ductwork to run 8' off of floor
- 6) Drain line: PVC w/ P-Trap and ball valve

| | | |
|--|--|---------------|
| Industrial Air Quality | | IAQ |
| 102 AG DRIVE Youngsville, NC 27596 P# 919-562-7181 F# 919-562-7182 | | |
| Project: TRW Fuji Valve | | |
| Drawing: Ductwork Layout | | |
| Date: 5/8/07 | | Drawn by: DDJ |
| Revision Date: | | |