



# Ductwork Layout for Line 6

Plan View

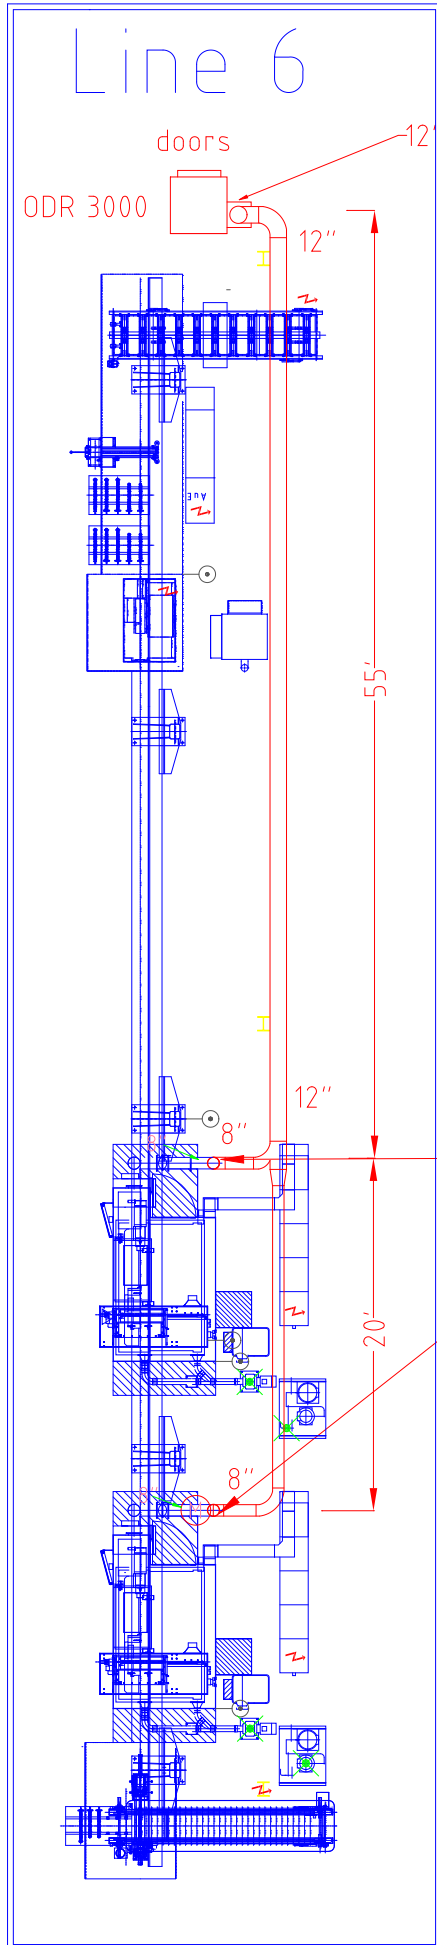

Connection Detail  
Side View  
To Main Trunkline

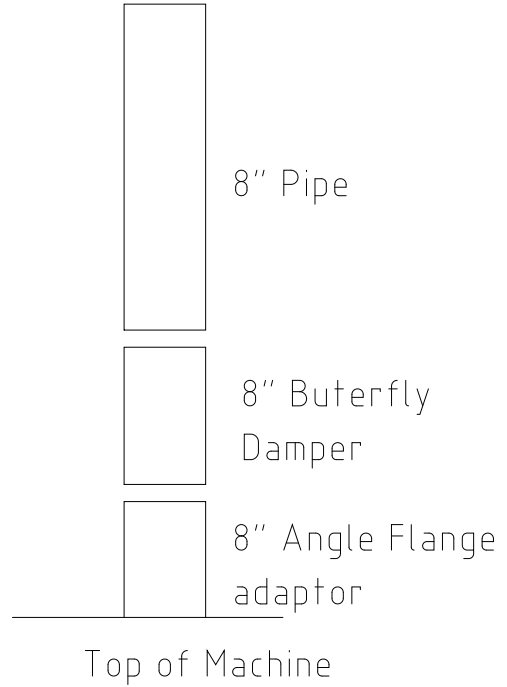

Connect to machine with an 8" angle flange adaptor. Then attach an 8" Butterfly damper, for airflow adjustments.

Notes:

- A) Hang ductwork from ceiling about 12' off of floor
- B) Attach 8" Angle flange adaptor to top of machine

Industrial Air Quality 102 AG DRIVE Youngsville, NC 27596 P# 919-562-7181 F# 919-562-7182		<b>IAQ</b>
Project: Systrand Presta		
Drawing: Ford Line 6 layout		
Date: 11/10/08	Drawn by: RAV	
Sheet No:		

