


Rework Ductwork Layout for Planet Pin DDR 2000

Plan View

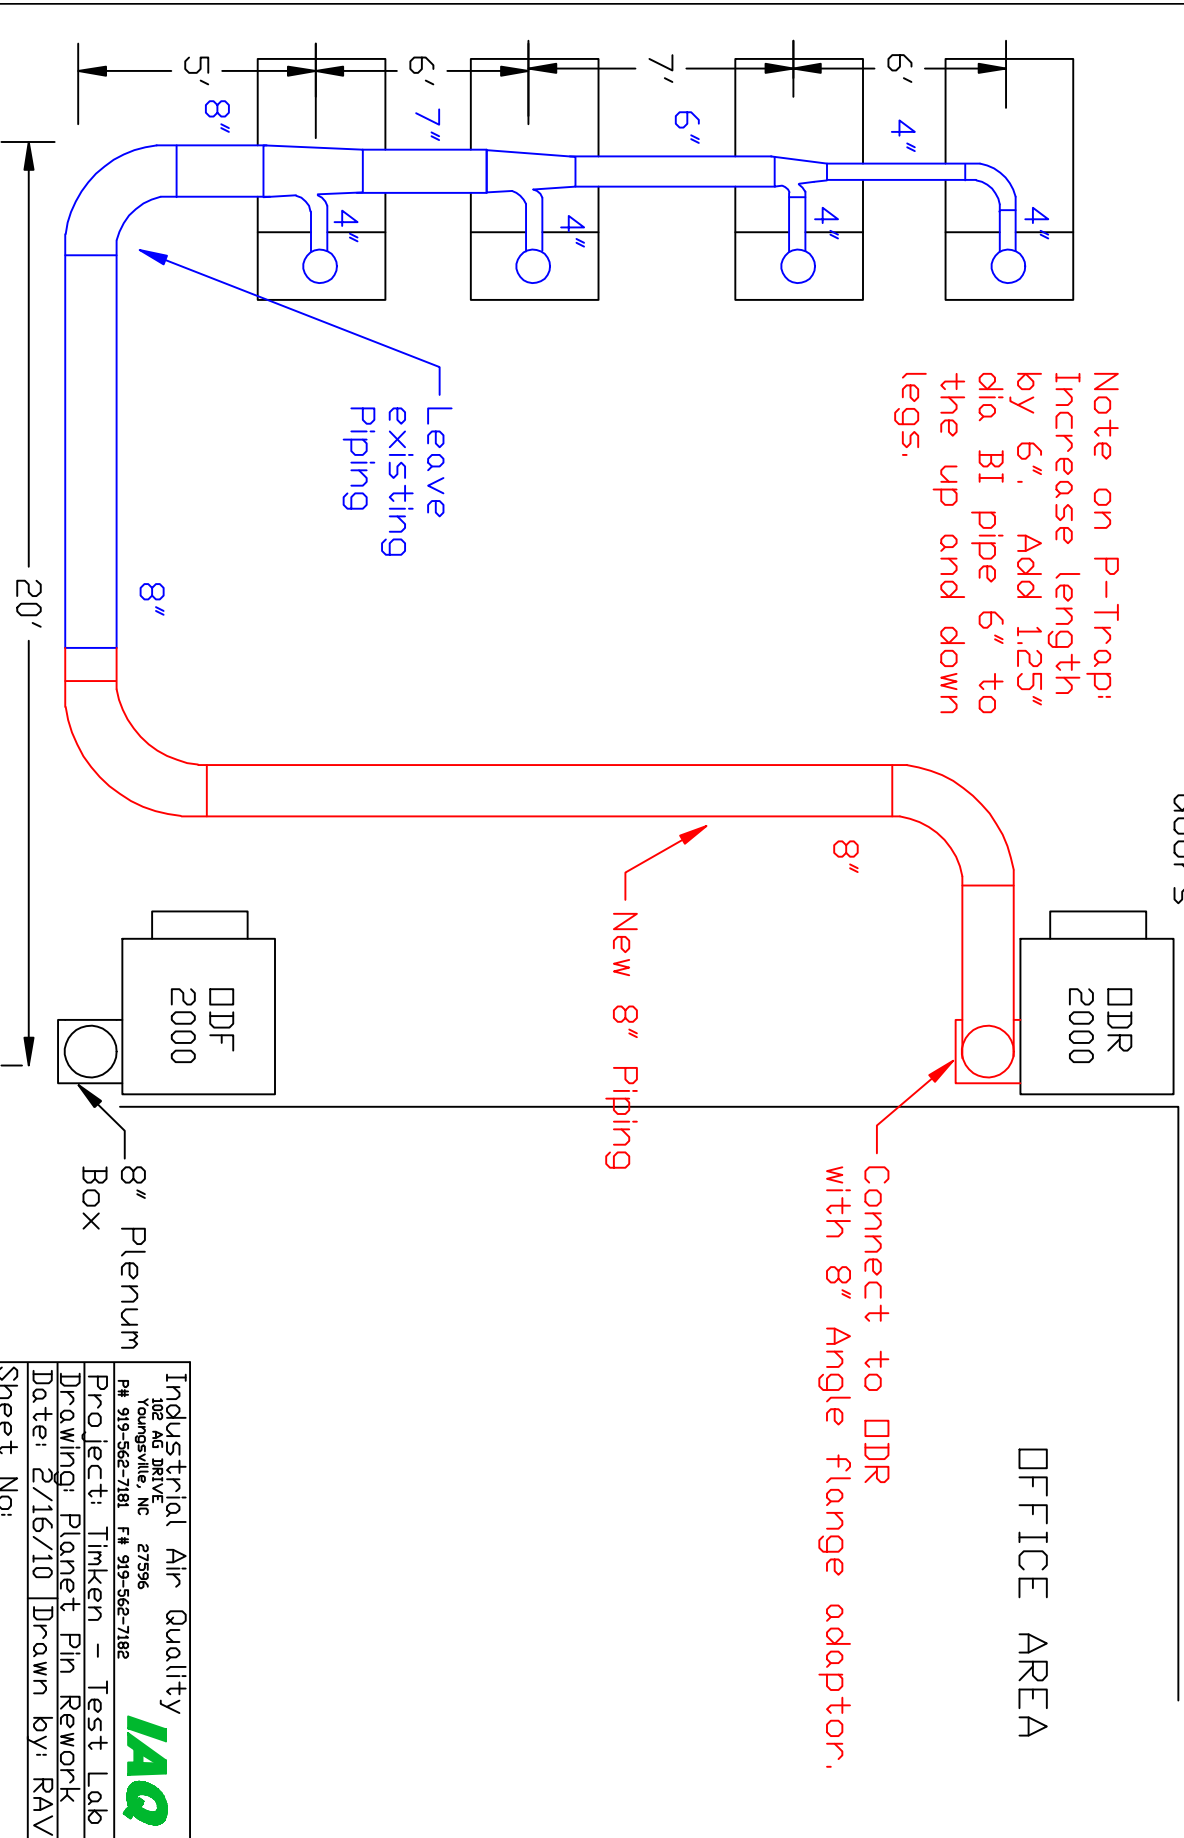

Note on P-Trap:
Increase length
by 6". Add 1.25"
dia BI pipe 6" to
the up and down
legs.

Leave
existing
Piping

Connect to DDR
with 8" Angle flange adaptor.

New 8" Piping

8" Plenum
Box

OFFICE AREA

Industrial Air Quality
102 AG DRIVE
Thomasville, NC 27396
PH 919-562-7181 F# 919-562-7182
Project: Timken - Test Lab
Drawing: Planet Pin Rework
Date: 2/16/10 Drawn by: RAV
Sheet No:

