



# Absolent Ductwork Layout for Grinder


## Plan View

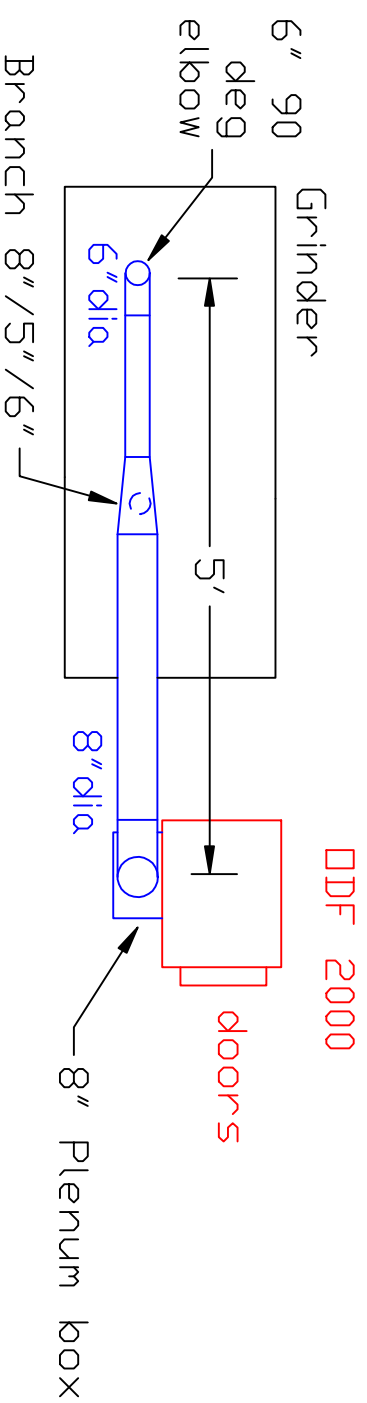

DDF 2000

## Side View

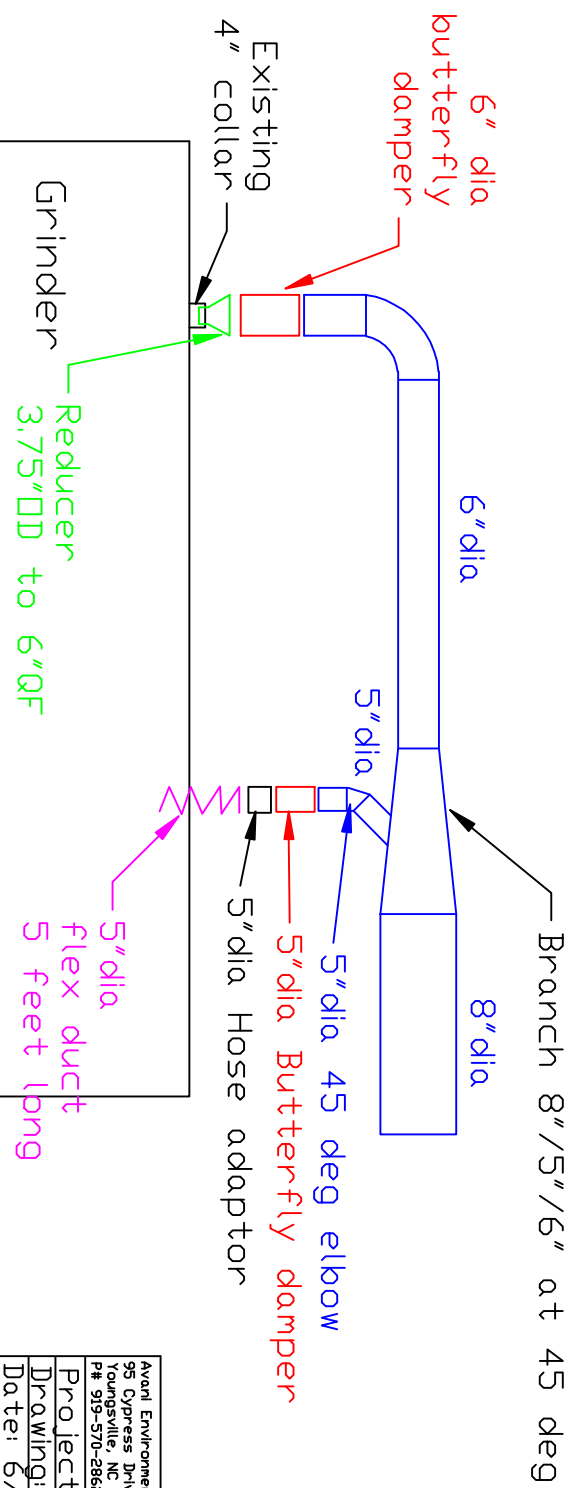

Avanti Environmental 95 Cypress Drive 27596 Raleighville, NC 28621 P# 919-570-2862 F# 919-570-2863	
	
Project:	Timken
Drawing:	Ductwork Layout
Date:	6/3/11
Drawn by:	RAV
Sheet No:	