




Absolent Ductwork Layout DDF 2000 - Blanchard Machine - K&B Duct Plan View

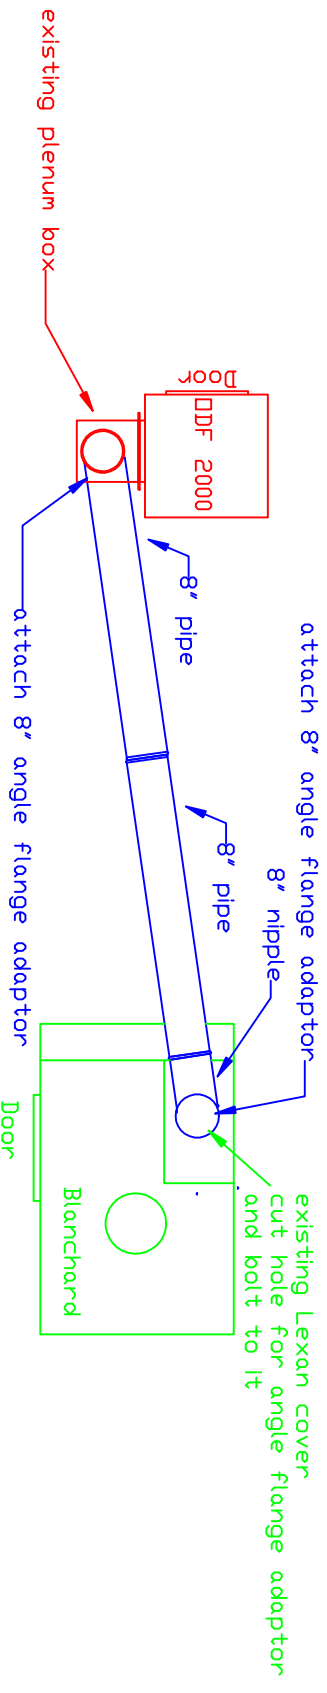

Side View

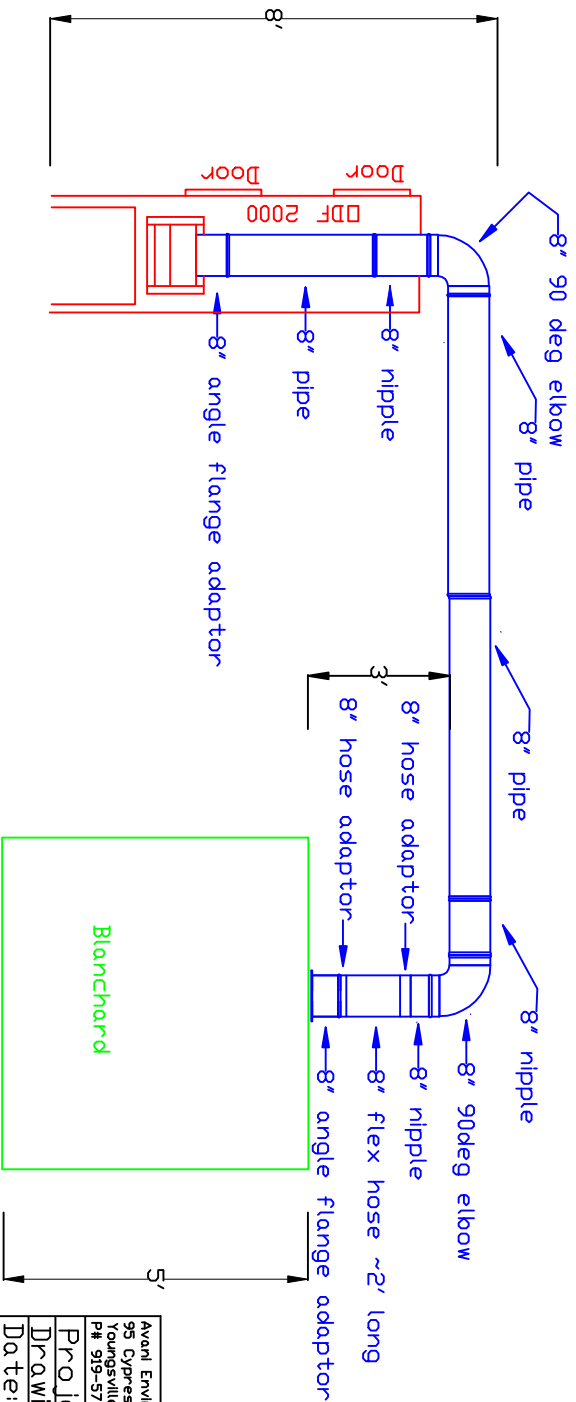

Avanti Environmental Intl. Inc. 95 Cypress Drive 27596 Raleighville, NC P# 919-570-2862 F# 919-570-2863	
	
Project: Timken Union SC	
Drawing: DDF 2000 Duct	
Date: 4/23/12 Drawn by: DDJ	
Sheet No:	