


Ductwork Layout for ODR 9000

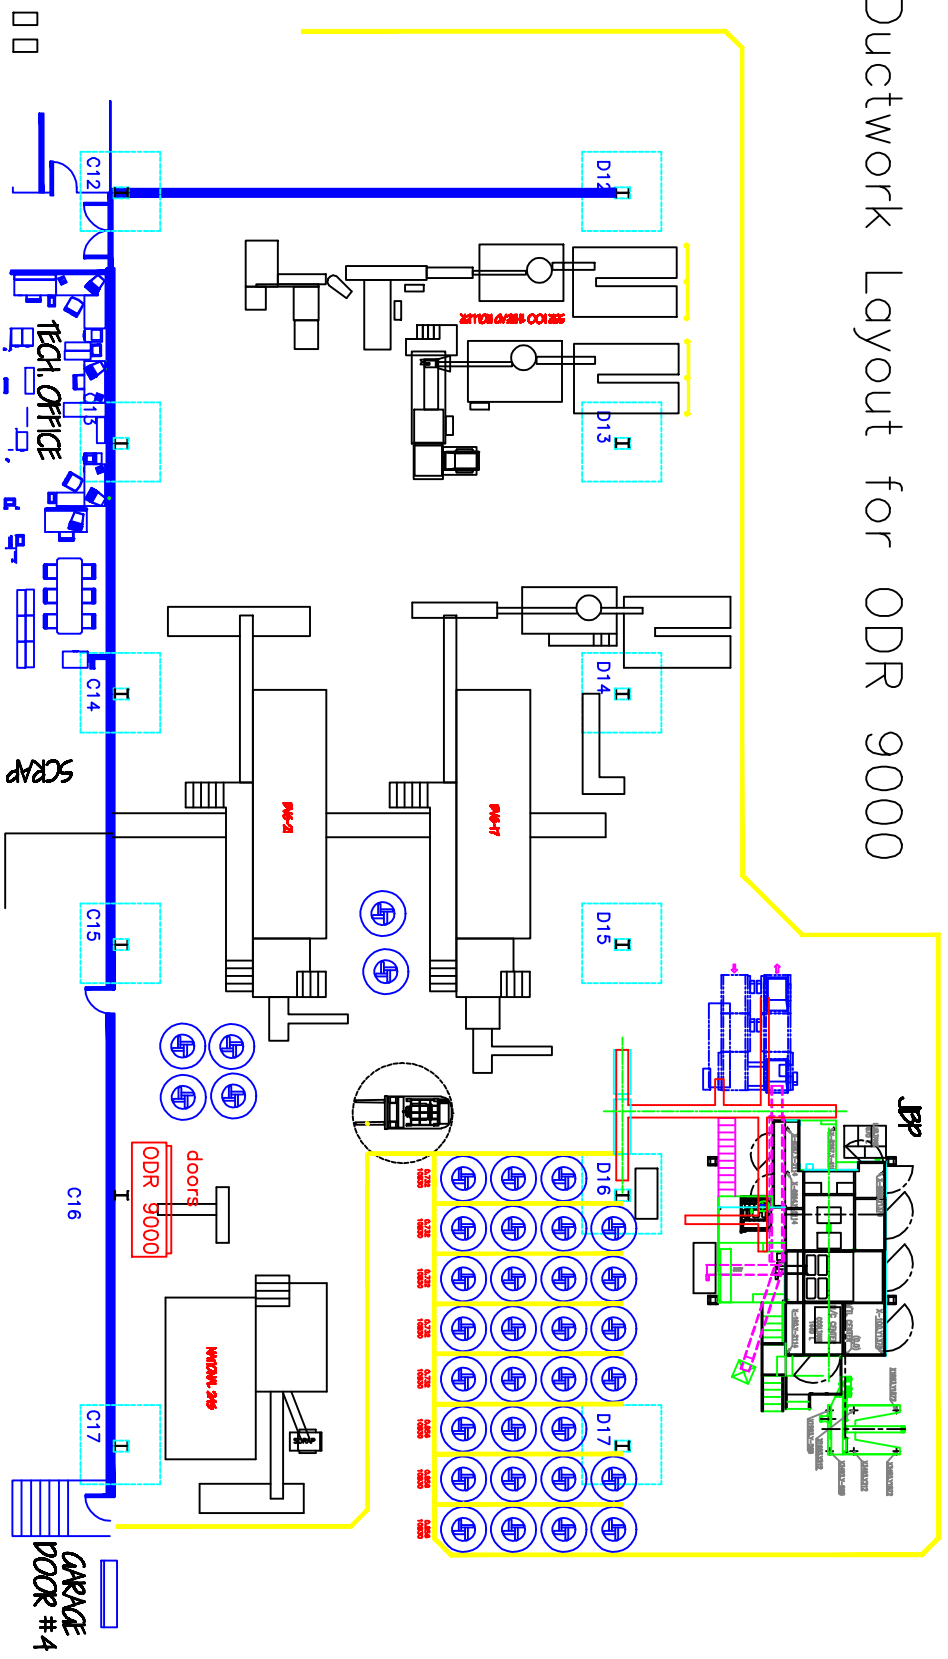

Industrial Air Quality
 100 26 DME
 Youngsville, NC 27596
 P# 919-562-7181 F# 919-562-7182
 Project: Unytile Drive
 Drawing: Ductwork layout
 Date: 9/11/09 Drawn by: RAV
 Sheet No:

