


Ductwork Layout Plan View

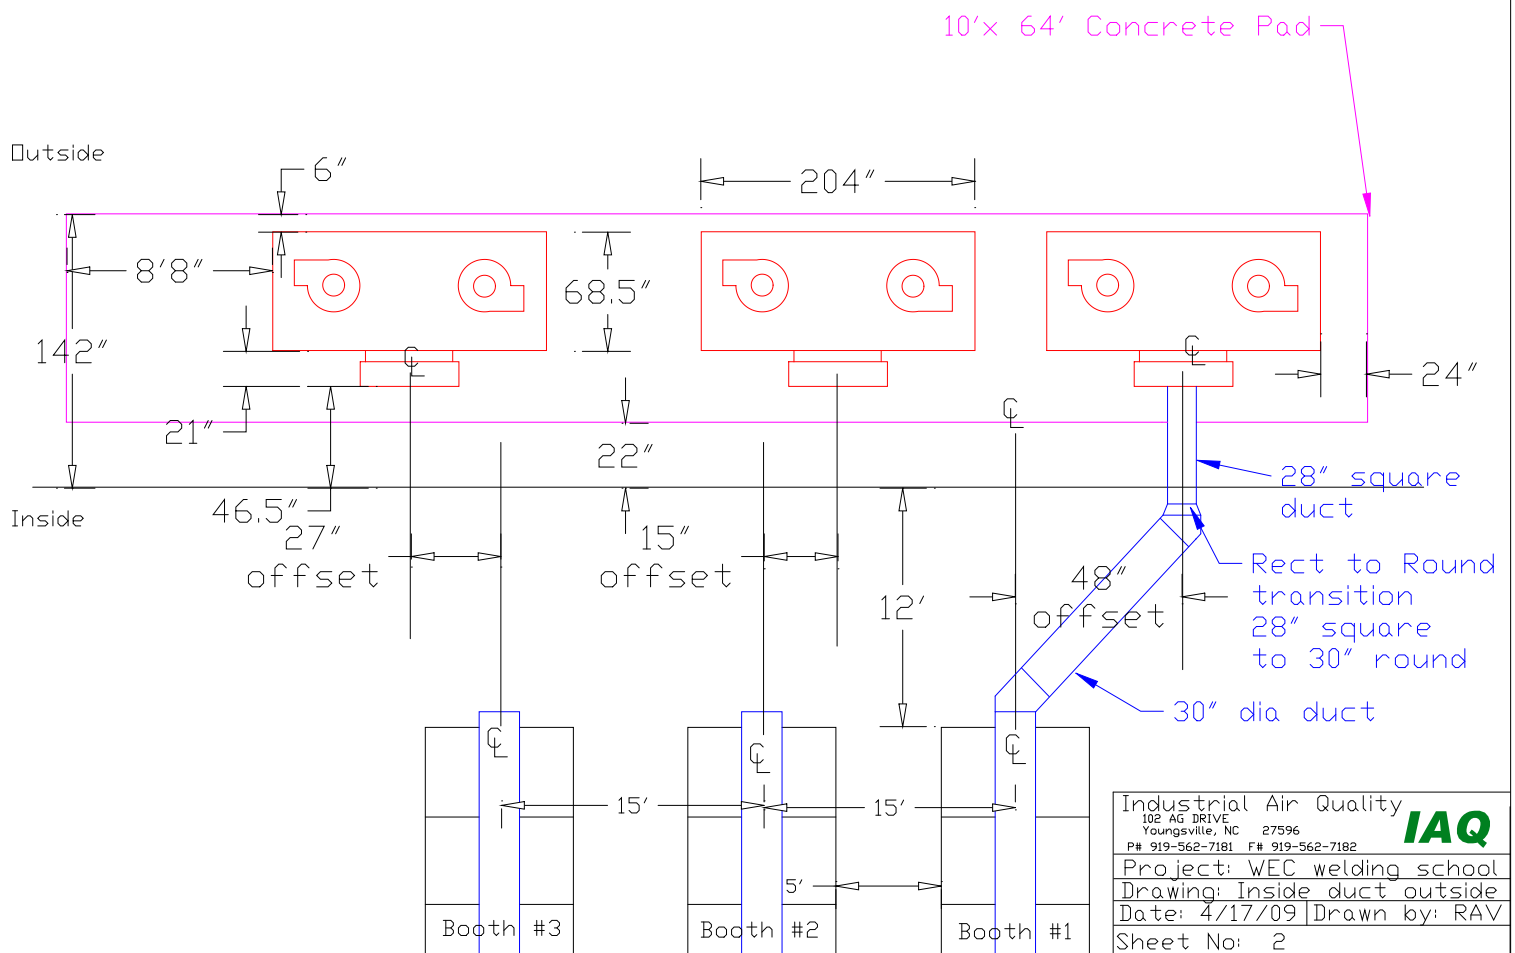

Industrial Air Quality		IAQ
102 AG DRIVE Youngsville, NC 27596		
P# 919-562-7181 F# 919-562-7182		
Project: WEC welding school		
Drawing: Inside duct outside		
Date: 4/17/09		Drawn by: RAV
Sheet No: 2		