



Ductwork layout for Index C200 machine

Plan View

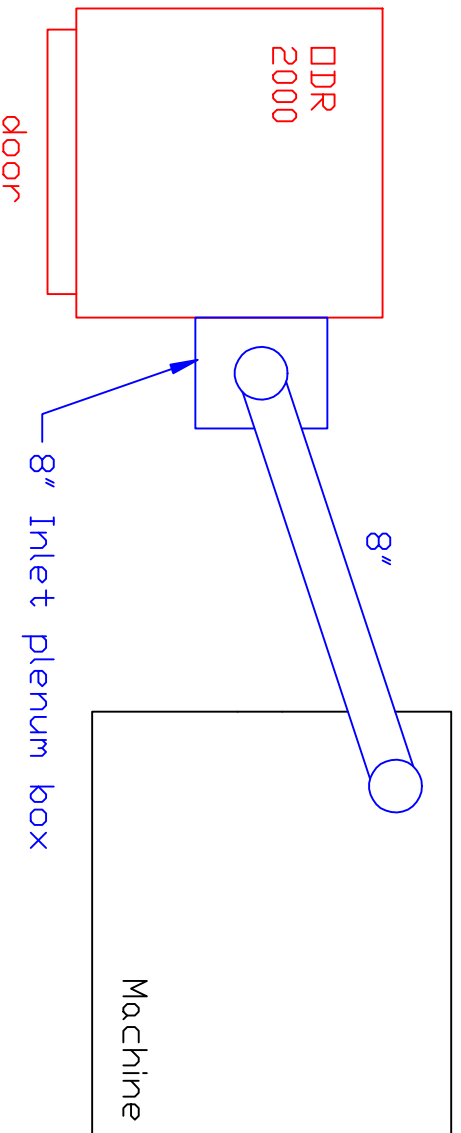

Notes:
A) Motor 3.5HP
3Phase 460volts. At
460 volts full load
amps are 5.2.

Side View

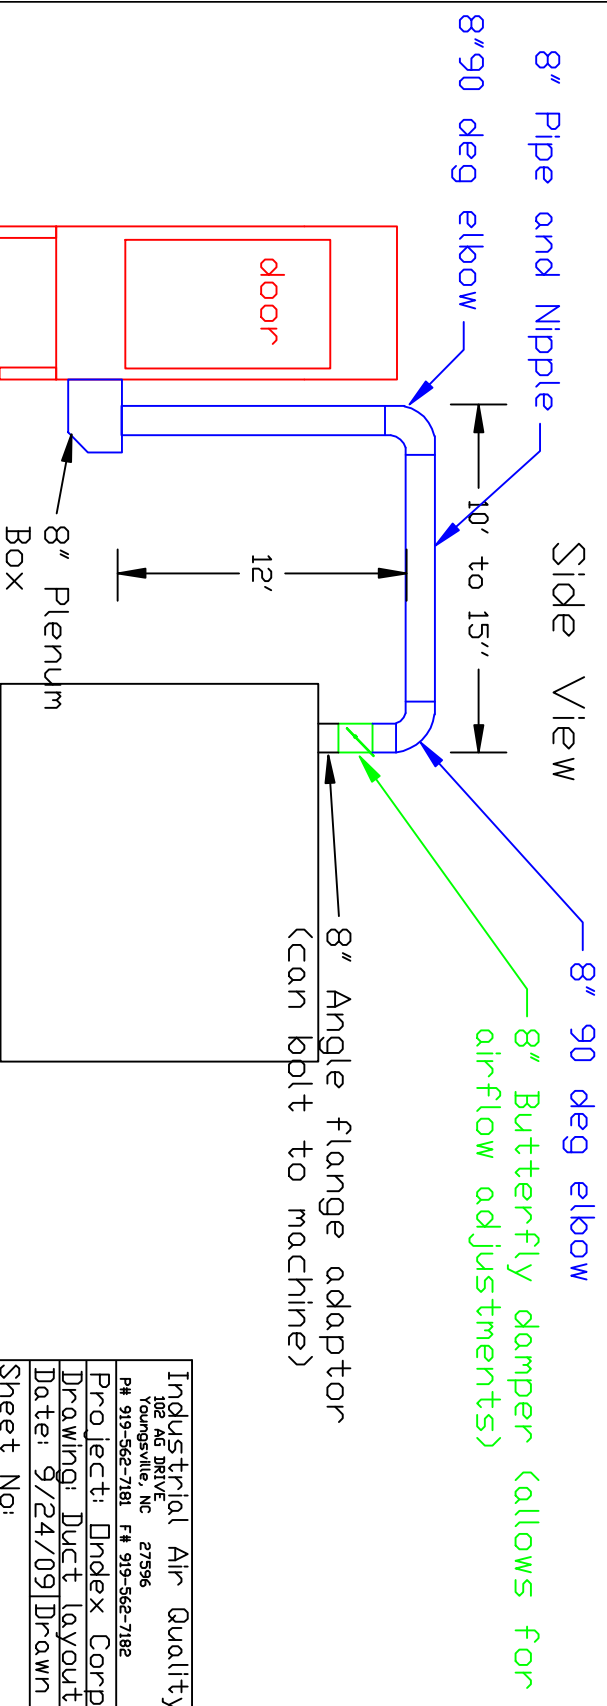

Industrial Air Quality
102 AG DRIVE
Toungesville, NC 27596
PH 919-562-7181 F# 919-562-7182
Project: Index Corp
Drawing: Duct layout
Date: 9/24/09 Drawn by: RAV
Sheet No:

