


Ductwork Layout for DDR 3000 Plan View

- Notes:
- A) Bottom of ductwork off of floor is 12'
 - B) Each drop will have Butterfly damper for airflow adjustment

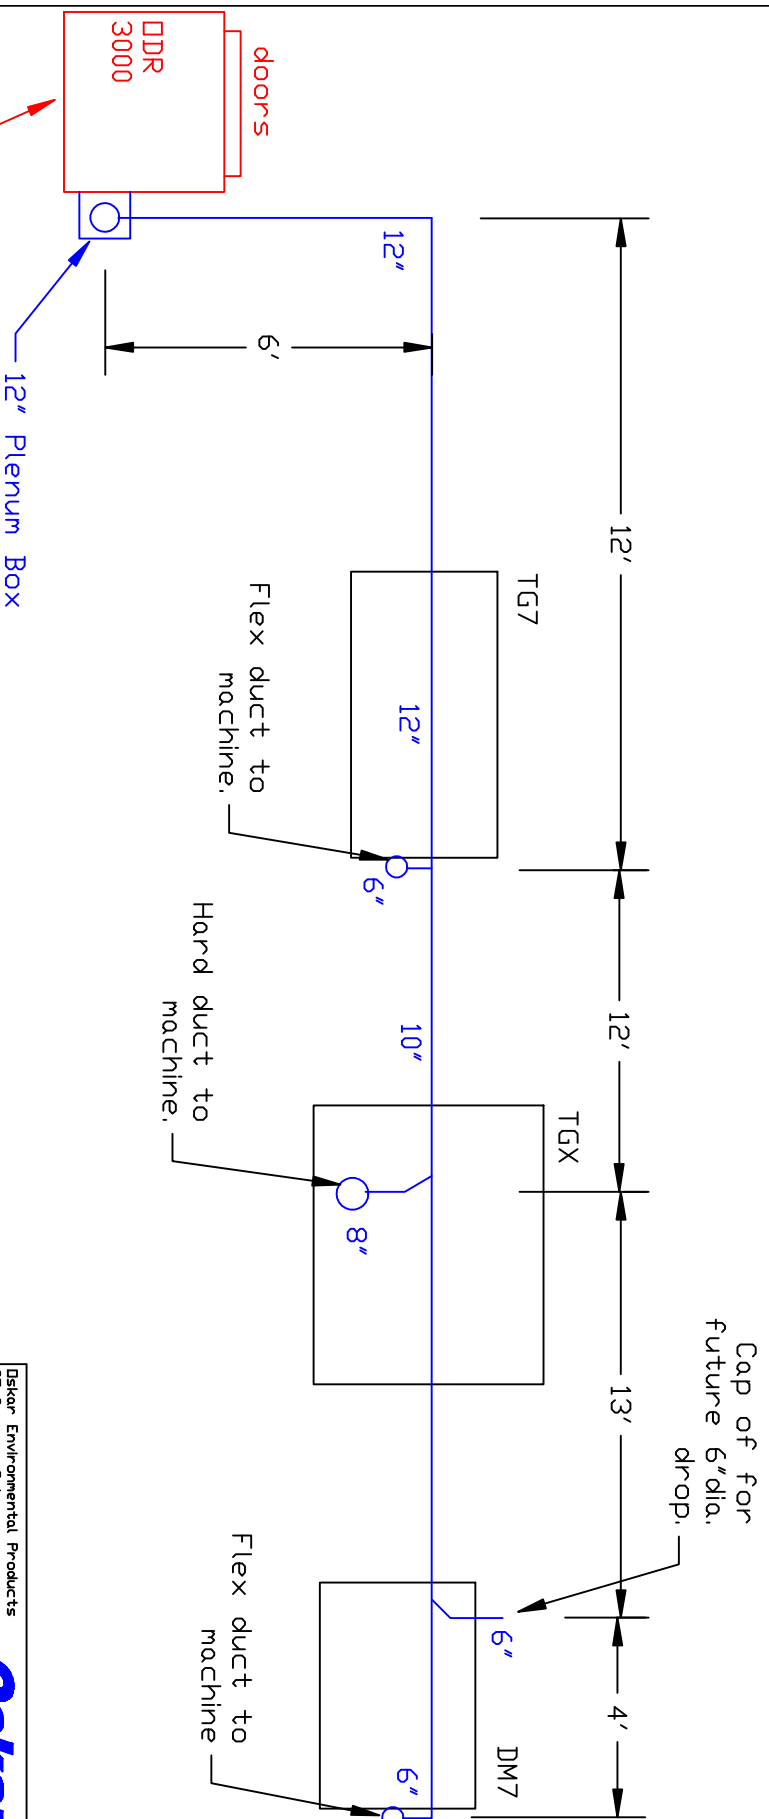

10Hp motor. At 480 volts
full load amps are 14.2.
DDR 3000 will sit on stand.

Oskar Environmental Products	
95 Cypress Drive	27596
Mountsville, NC	
# 919-570-2862	F# 919-570-2863
Oskar	
Project: Smith & Nephew	
Drawing: Ductwork Layout	
Date: 3/19/10	Drawn by: RAV
Sheet No:	