


# Ductwork Layout for DDR 2000 Plan View

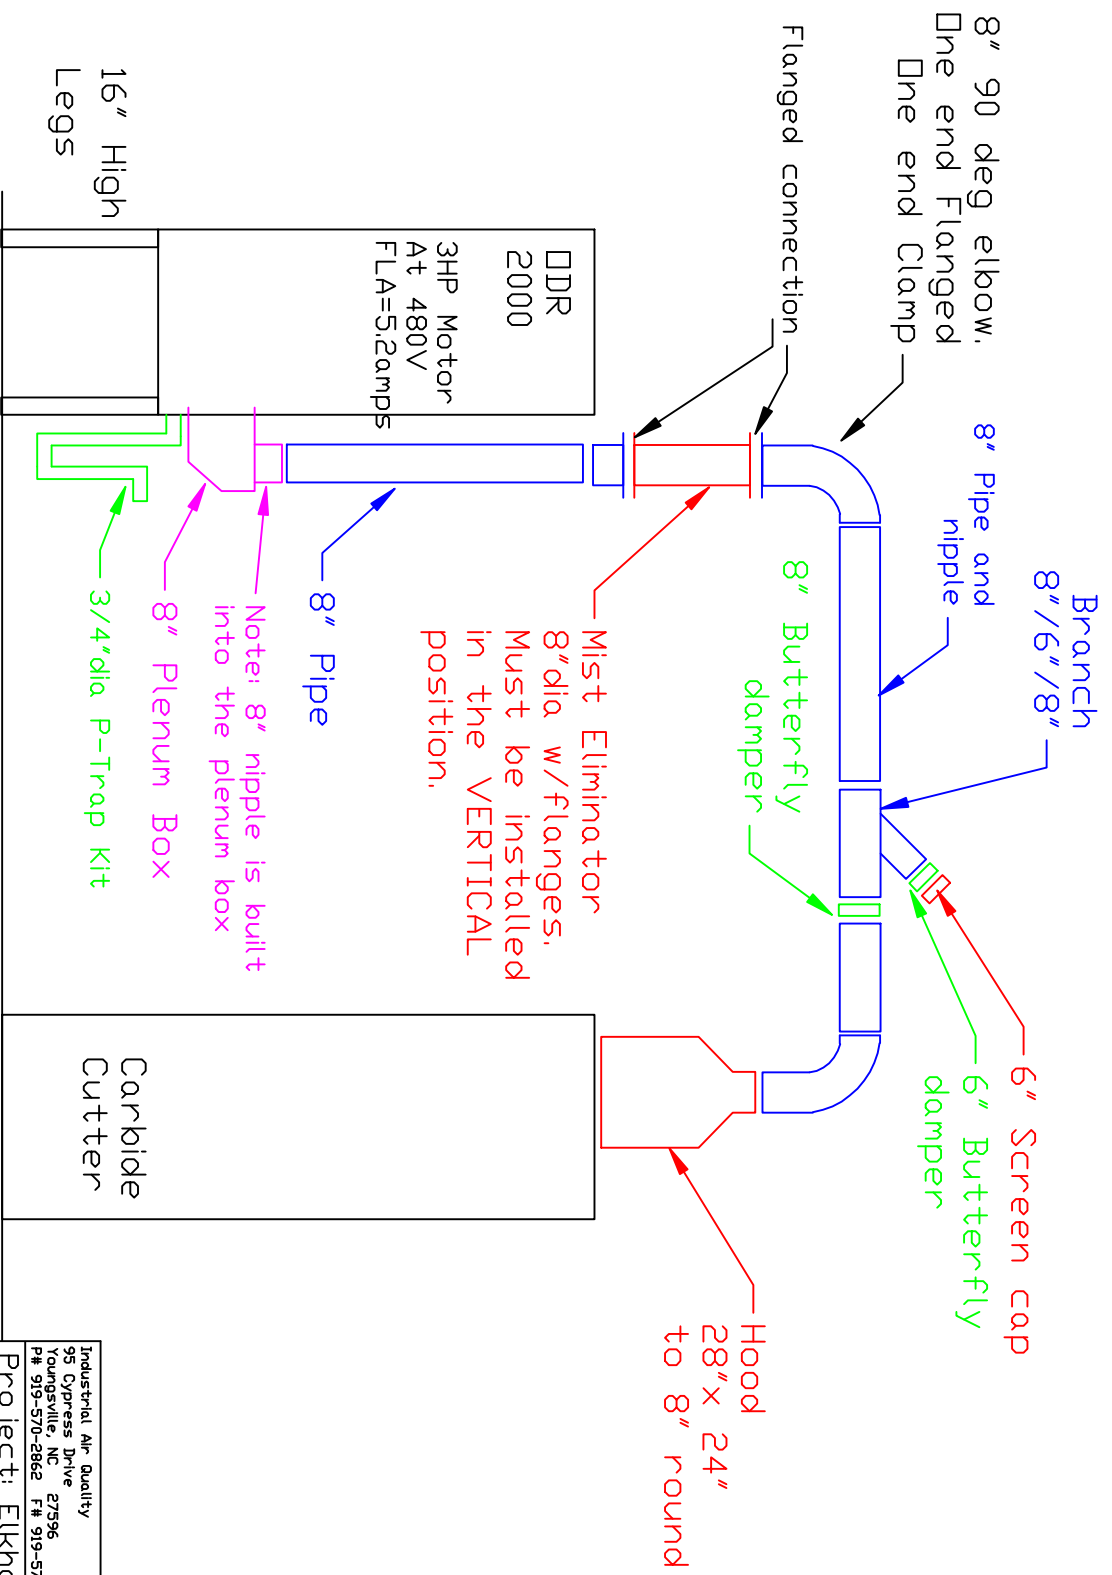

Industrial Air Quality  
95 Cypress Drive 27596  
Raleighville, NC  
P# 919-570-2862 F# 919-570-2863

**IAQ**

Project: Elkhart Products  
Drawing: Ductwork layout  
Date: 2/10/10 Drawn by: RAV  
Sheet No: