


Ductwork Layout for DDF-2000S

Plan View

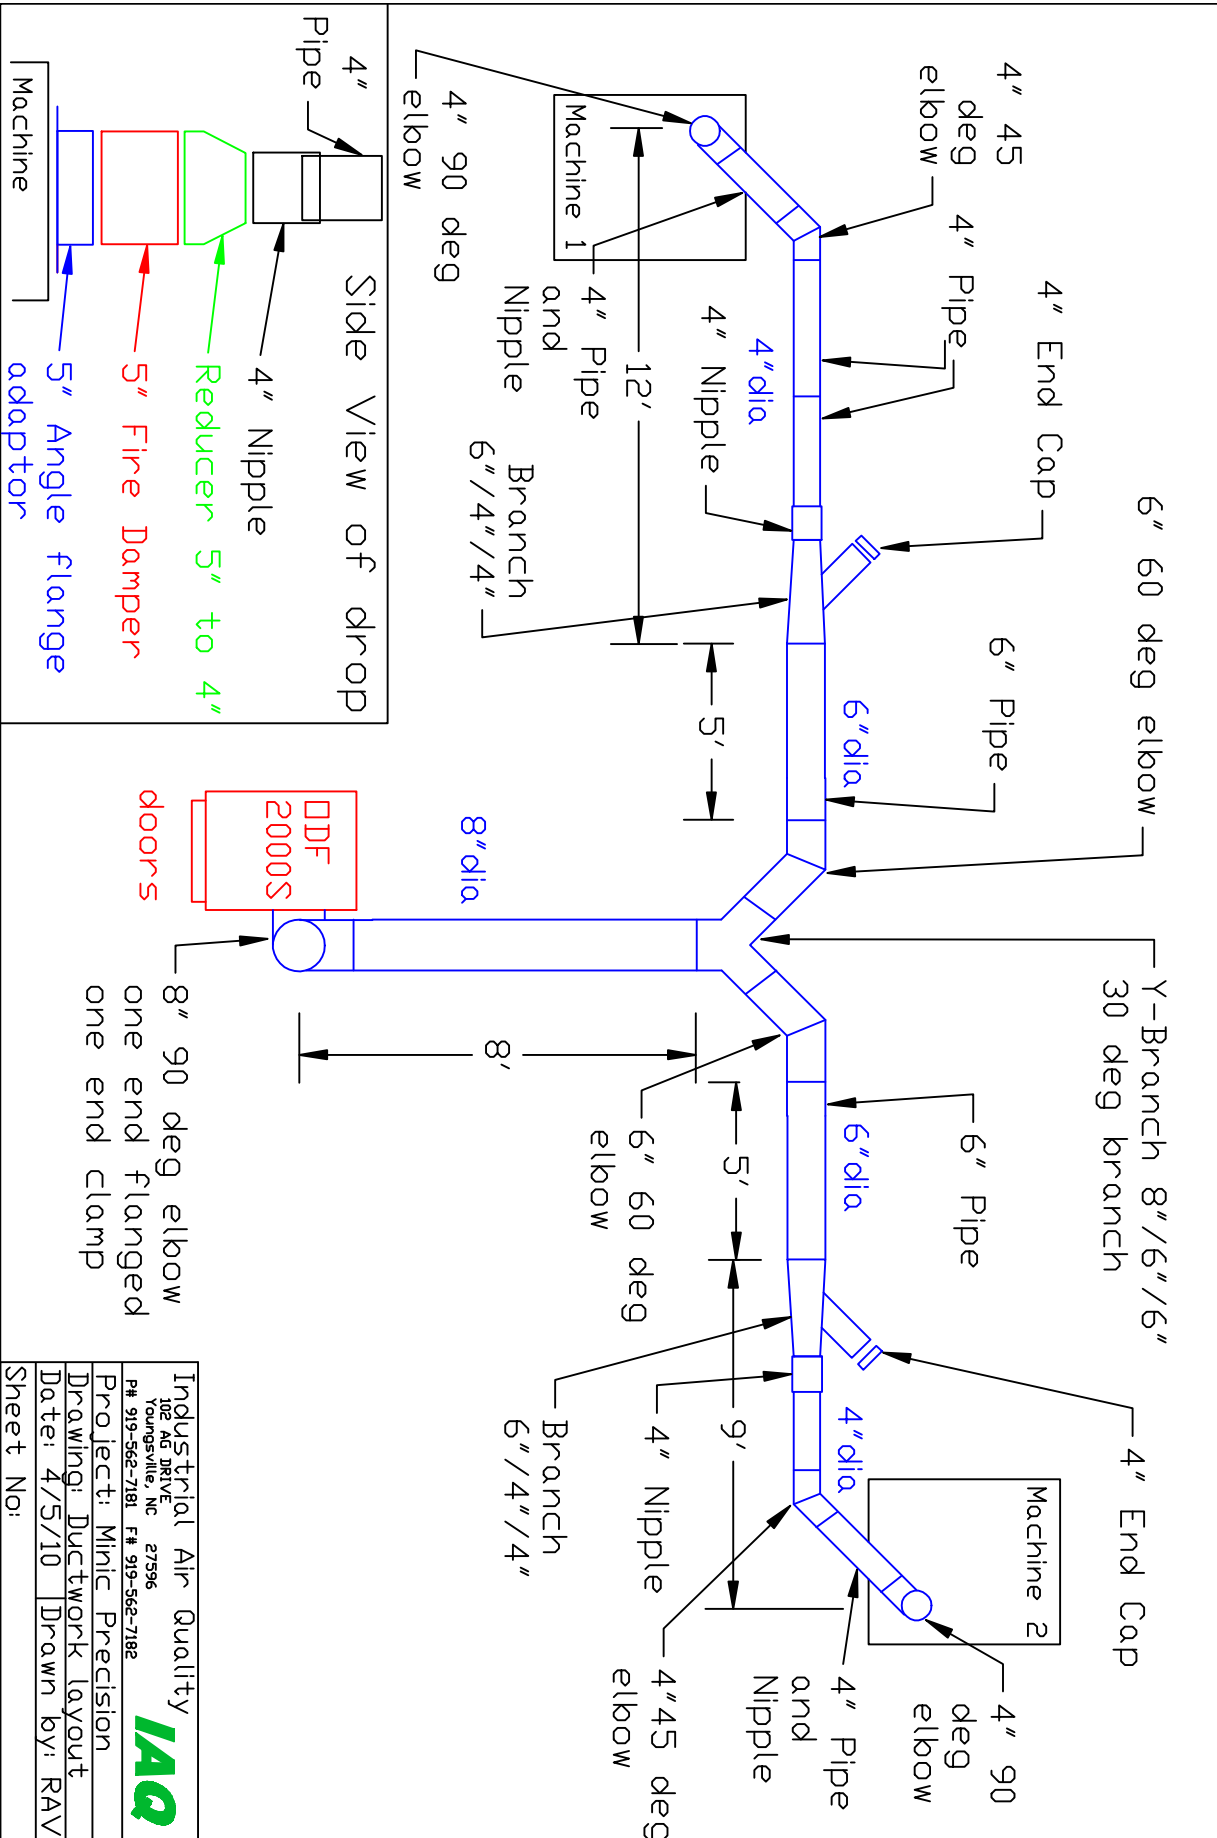

Industrial Air Quality <small>102 AG DRIVE TOURNAVILLE, NC 27596 PH 919-562-7181 F# 919-562-7182</small>
IAQ
Project: Minic Precision Drawing: Ductwork layout Date: 4/5/10 Drawn by: RAV
Sheet No: