


# Rect to Round Transition Plan View

Outside  
Inside

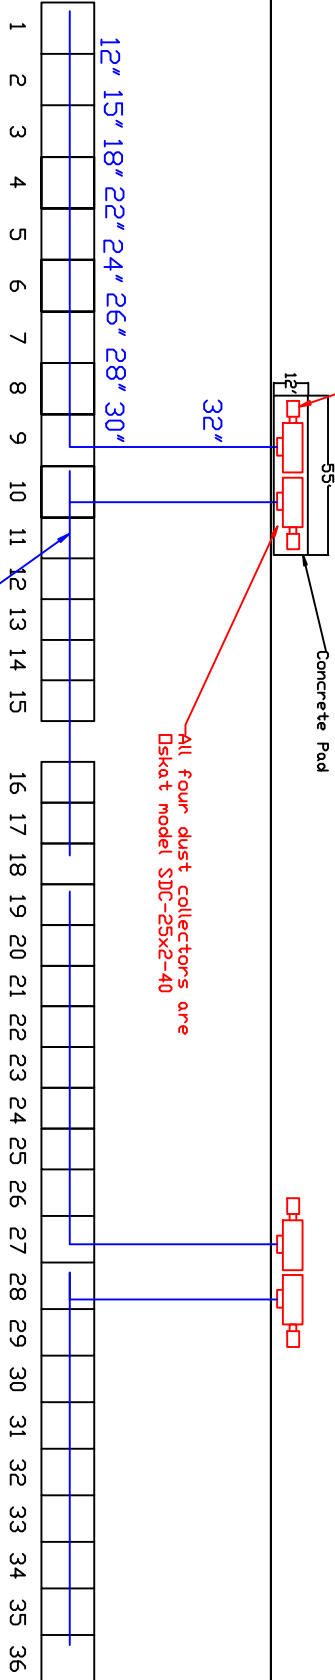

All four fans are the same,  
60 HP 480volts 3Phase  
Discharge of fan will have  
a No-Loss Stack on it.

All four dust collectors are  
Dskat model SDC-25x2-40

Ductwork,  
9 Booths will go to one collector

- Notes:
- A) All drops are 12' diameter to the booths
  - B) Dskat collectors are designed for 25,000CFM each
  - C) Bottom of ductwork about 17' off of floor

Blair Environmental Products 90 Drexels Drive P.O. Box 2796 Ft. Worth, TX 76101-0279 Ph: 817-370-8865 Fax: 817-370-8863	
Project: AP Exhaust Drawing: Ductwork Layout Date: 3/16/10 Drawn by: RAV Revision: 1 3/30/10	