



Aksolent Ductwork Layout for Grinder

Plan View

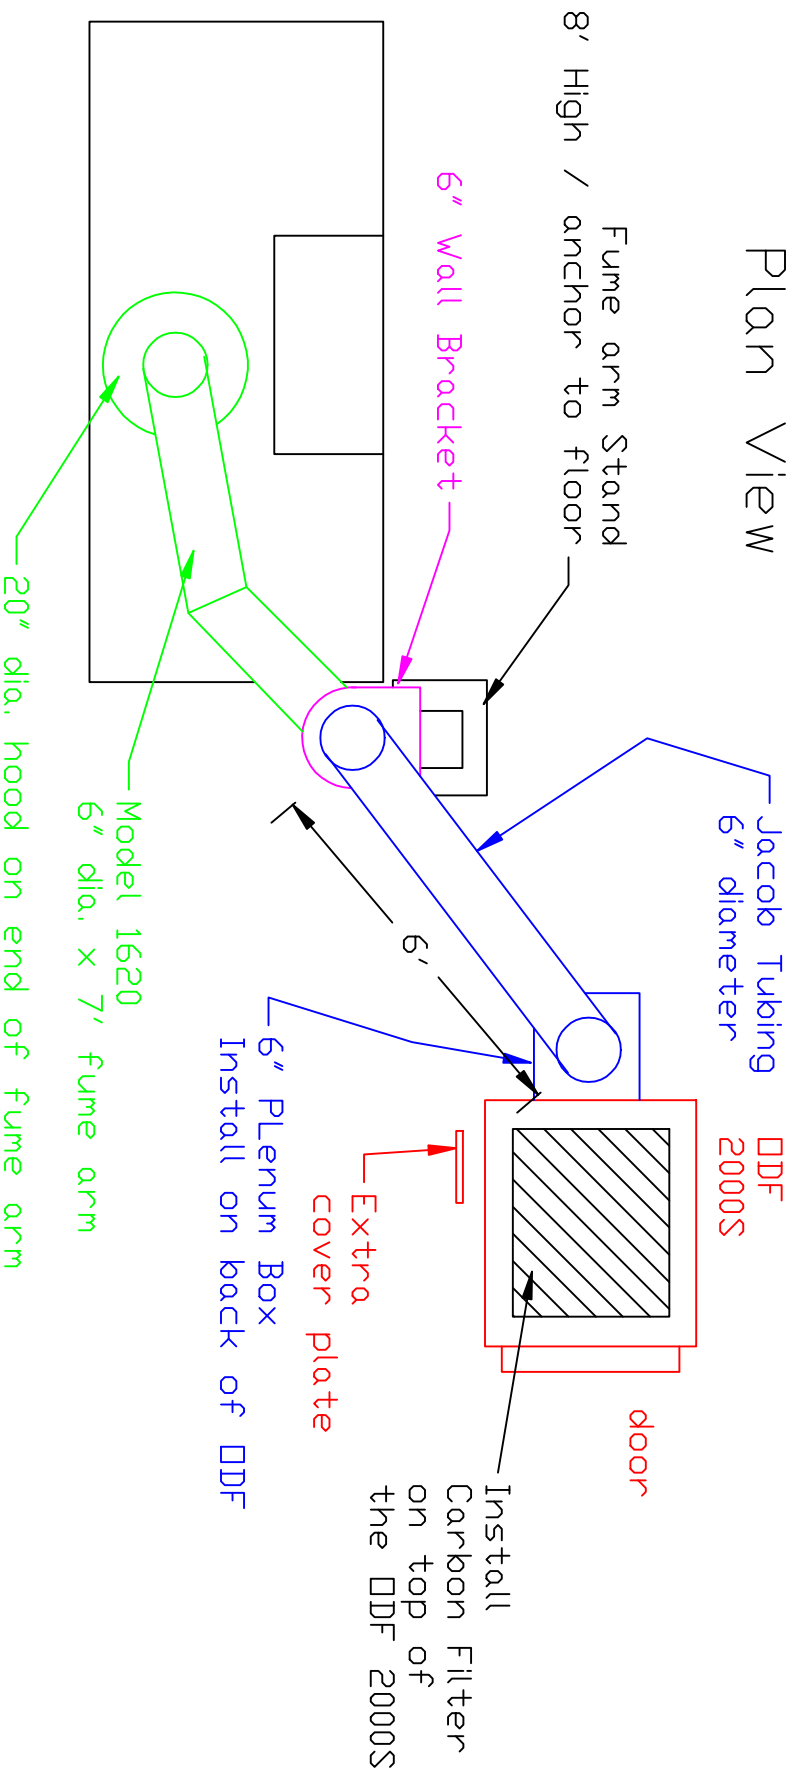

Notes:

- A) DDF 2000S has a 3.5 HP motor. Full load amps at 460 volts are 5.5amps.
- B) The Carbon filter mounts directly on to the top of the DDF 2000S outlet.
- C) P-Trap Kit to be installed on drain outlet of DDF 2000S.

Avanti Environmental 95 Cypress Drive 27596 Raleighville, NC P# 919-570-2862 F# 919-570-2863	
	
Project:	Accellent
Drawing:	Ductwork Layout
Date:	3/7/11
Drawn by:	RAV
Sheet No:	