


Ductwork Layout for Header #50

Plan View

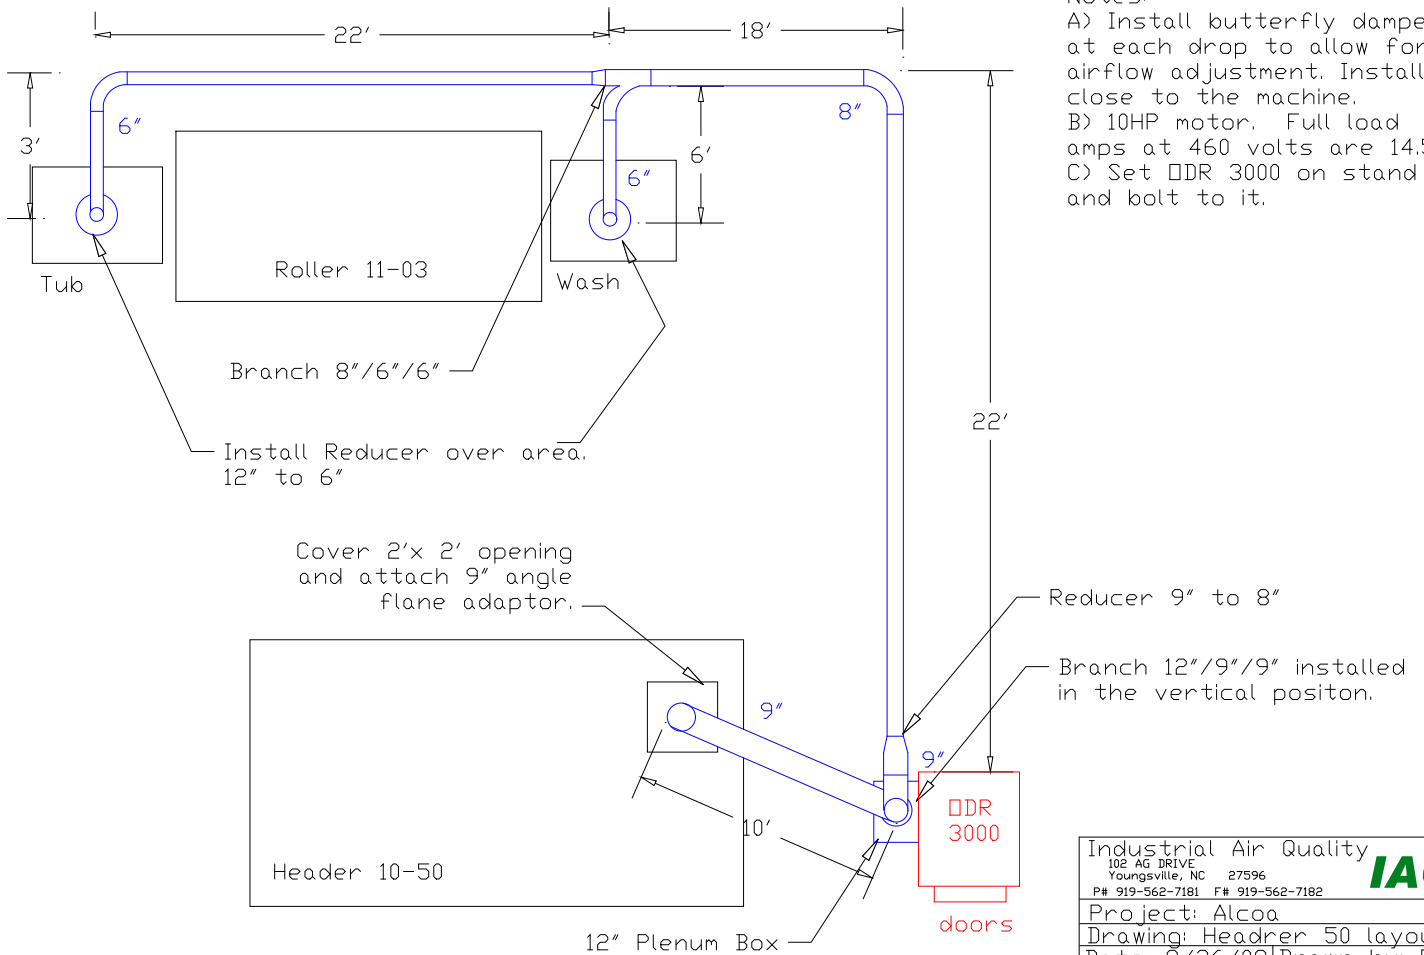

Industrial Air Quality		IAQ
102 AG DRIVE Youngsville, NC 27596		
P# 919-562-7181	F# 919-562-7182	
Project: Alcoa		
Drawing: Header 50 layout		
Date: 9/26/08		Drawn by: RAV
Sheet No:		