


Angelo State University

(12) WB-1066 (12) 1620 Arm

(Bicky reconst)
 2/16

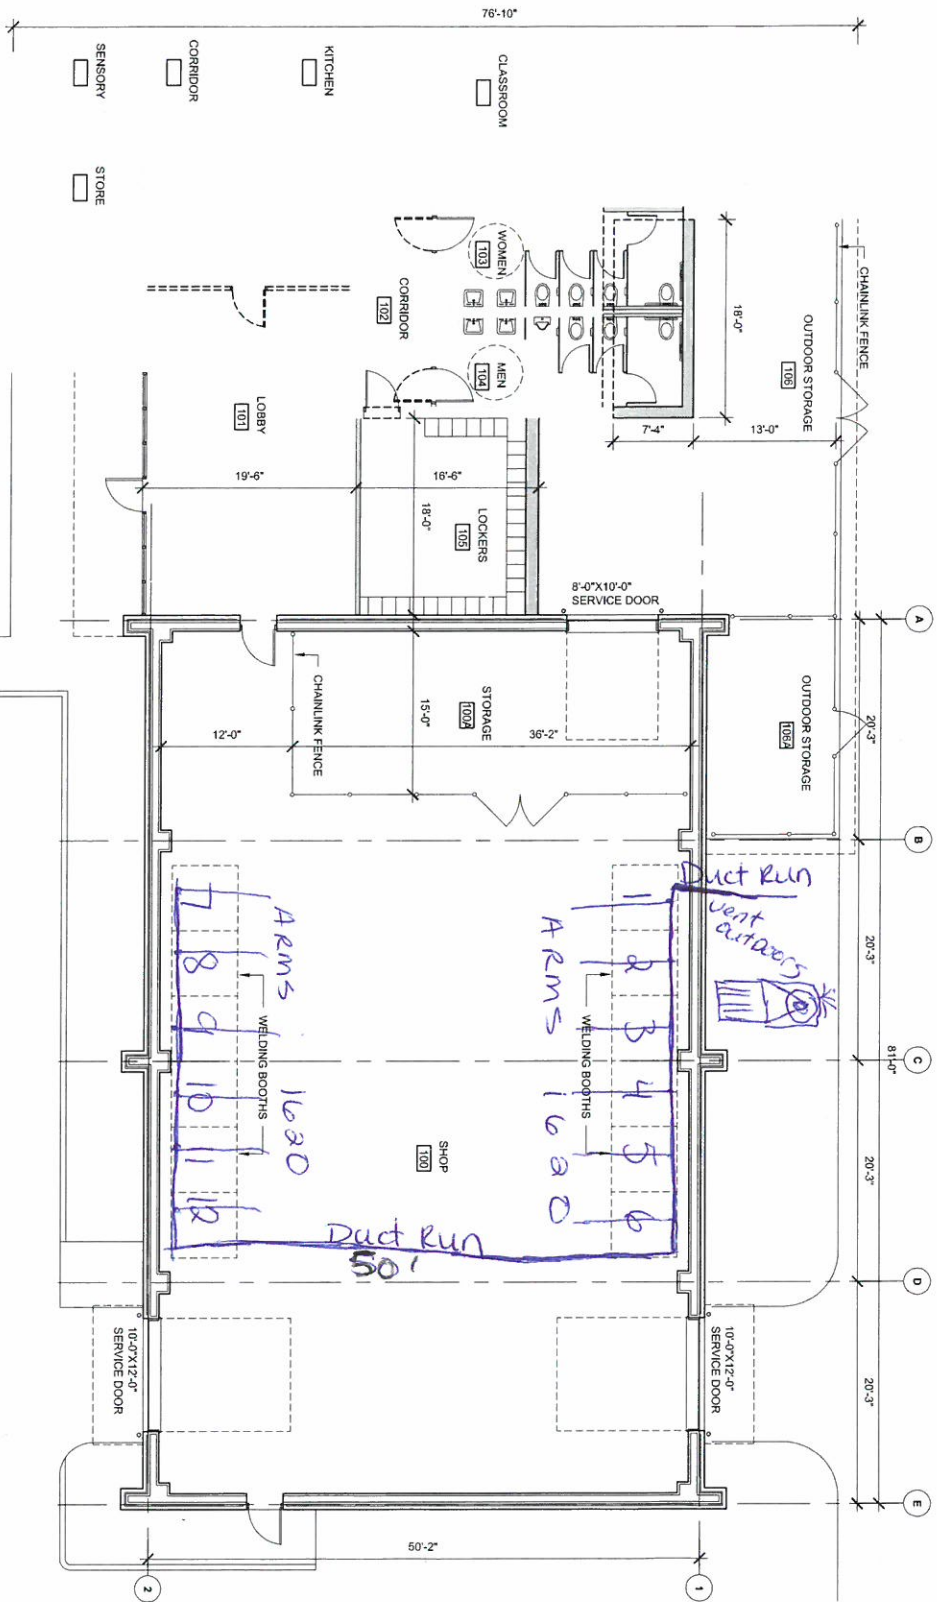

4-16 Dust collector (Act)
 30 hp Fan
 Silencer, Damper, inlet Flange, All in one Board

TRUE PLAN
 NORTH NORTH
 1 FLOOR PLAN
 SCALE: 3/8" = 1'-0"

K&B Duct

NOT FOR CONSTRUCTION

Mayer-Rousselot Agricultural Education Training Center
 Angelo State University
 7945 Grape Creek Rd. San Angelo, Texas

CasaBella ARCHITECTS
 3821 KIMBER TRACE, SUITE 104
 AUSTIN, TEXAS 78738
 PHONE: 512.458.5700
 FAX: 512.458.5795

Structural Engineer
 Stefano Lucvano Structures, LLP
 12000 Highway 19, Suite 100
 Houston, TX 77058
 License No. 13083
 Civil Engineer
 Agnew Associates, Inc.
 10000 Highway 19, Suite 100
 Houston, TX 77058
 License No. 13083
 Civil Engineer
 Capstone Engineering
 10000 Highway 19, Suite 100
 Houston, TX 77058
 License No. 13083

REVISIONS		
NO.	DATE	DESCRIPTION

FLOOR PLAN
 A1.1