


Ductwork Layout for Maco

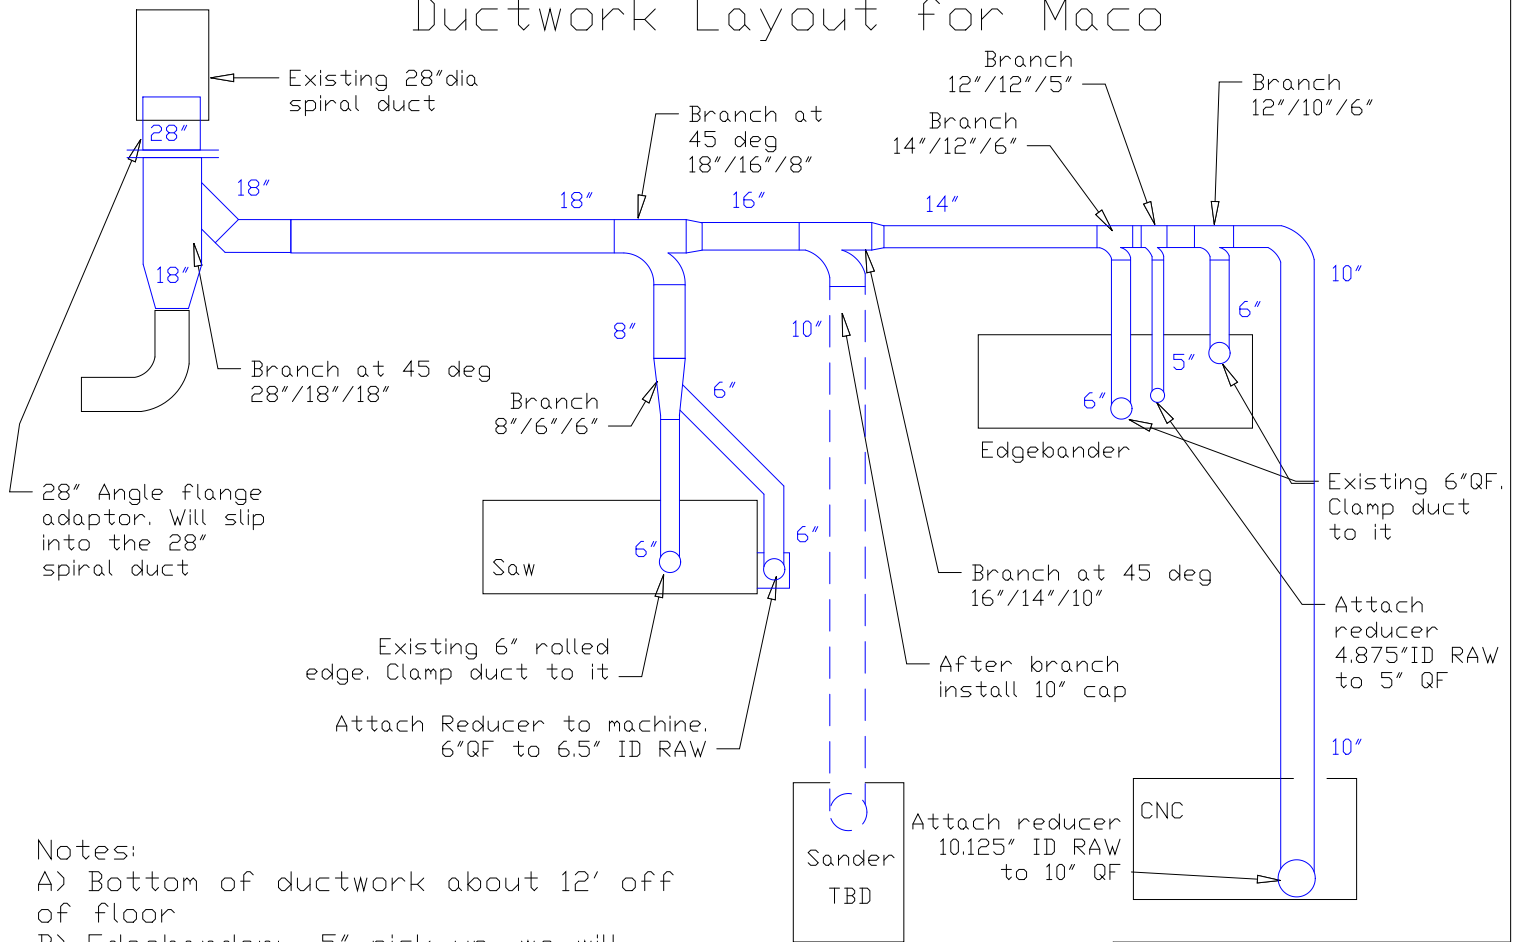

Notes:

- A) Bottom of ductwork about 12' off of floor
- B) Edgebänder: 5" pick up, we will try to hard duct but may require flex due to space limitations

Industrial Air Quality		IAQ
102 AG DRIVE Youngsville, NC 27596		
P# 919-562-7181 F# 919-562-7182		
Project: Maco		
Drawing: Ductwork layout		
Date: 7/7/08	Drawn by: RAV	
Revision Date:		