


Ductwork Layout

Side View

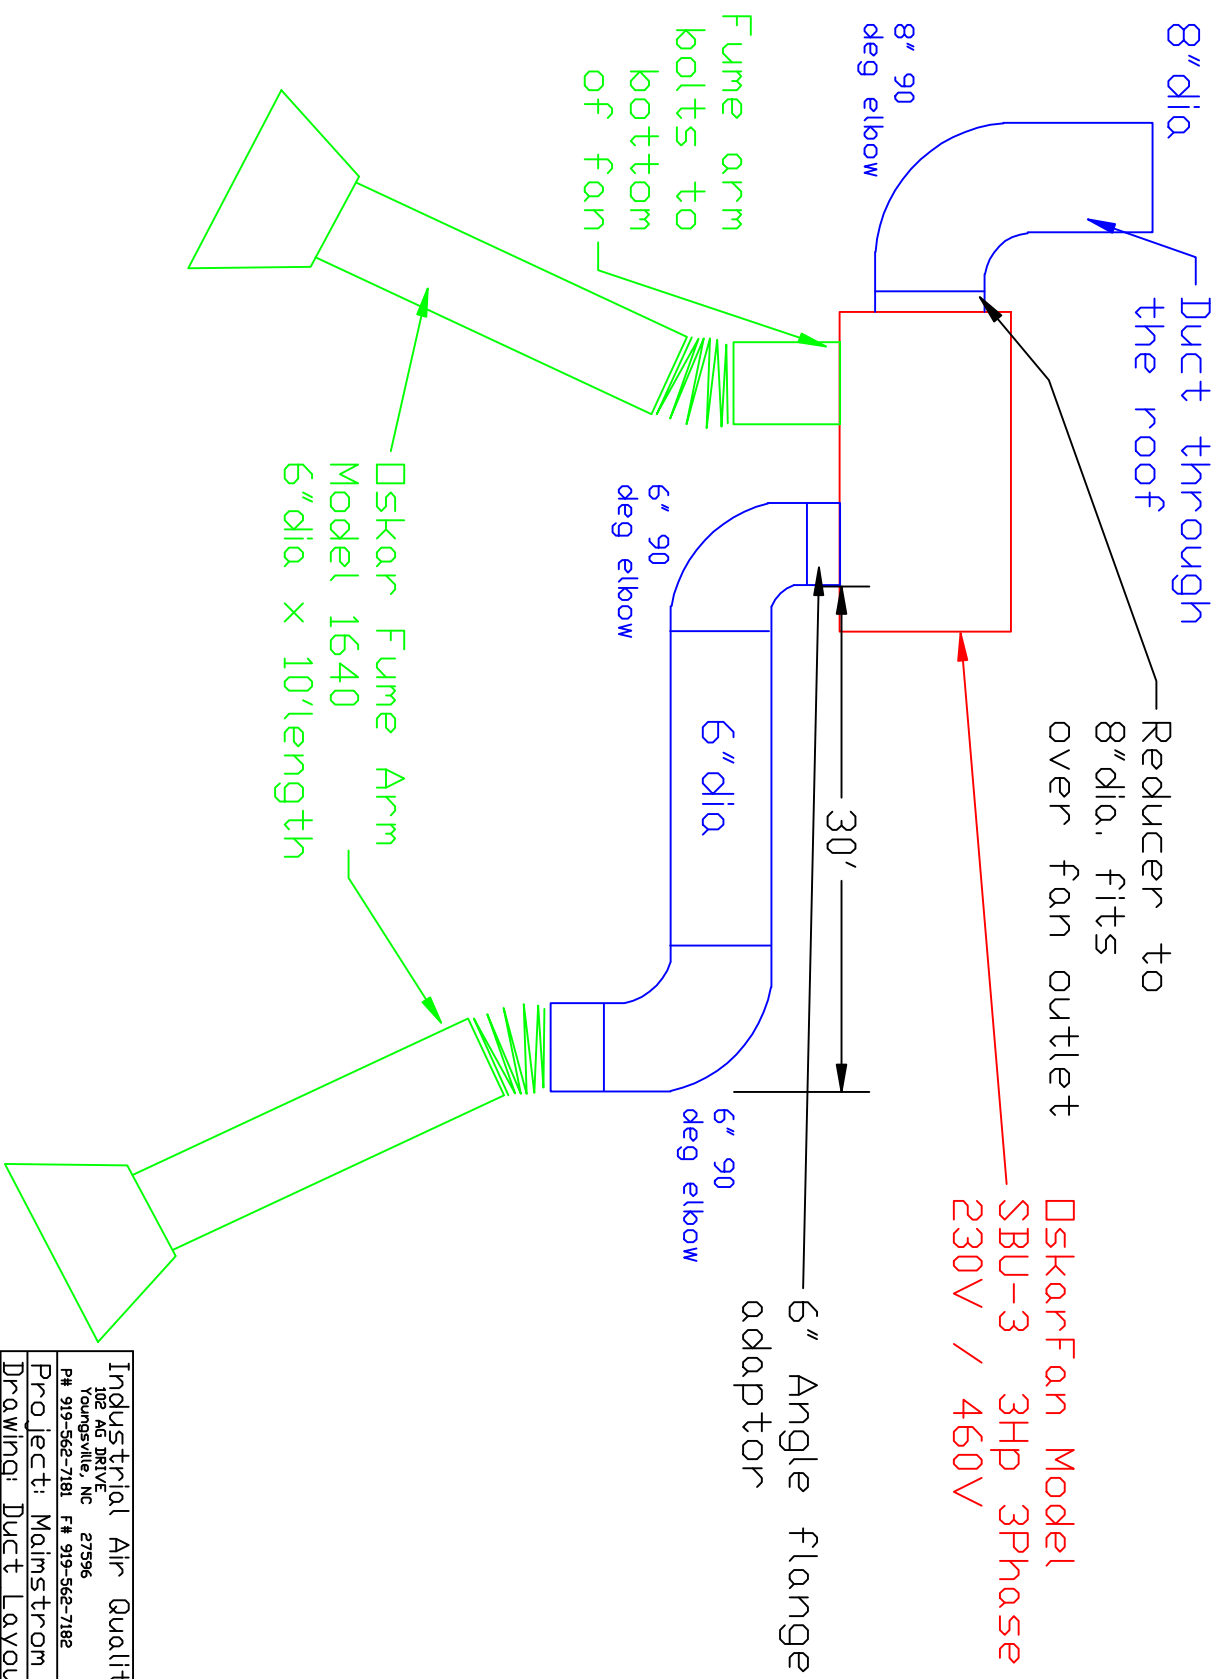

DSKAR Fan Model
SBU-3 3HP 3Phase
230V / 460V

Reducer to
8" dia. fits
over fan outlet

6" Angle flange
adaptor

DSKAR Fume Arm
Model 1640
6" dia x 10' length

Fume arm
bolts to
bottom
of fan

Industrial Air Quality
102 AG DRIVE
TOURNAVILLE, NC 27596
PH 919-562-7181 F# 919-562-7182
Project: Malmstrom AFB
Drawing: Duct Layout
Date: 10/16/09 Drawn by: RAV
Revised:

