


Ductwork Layout Plan View

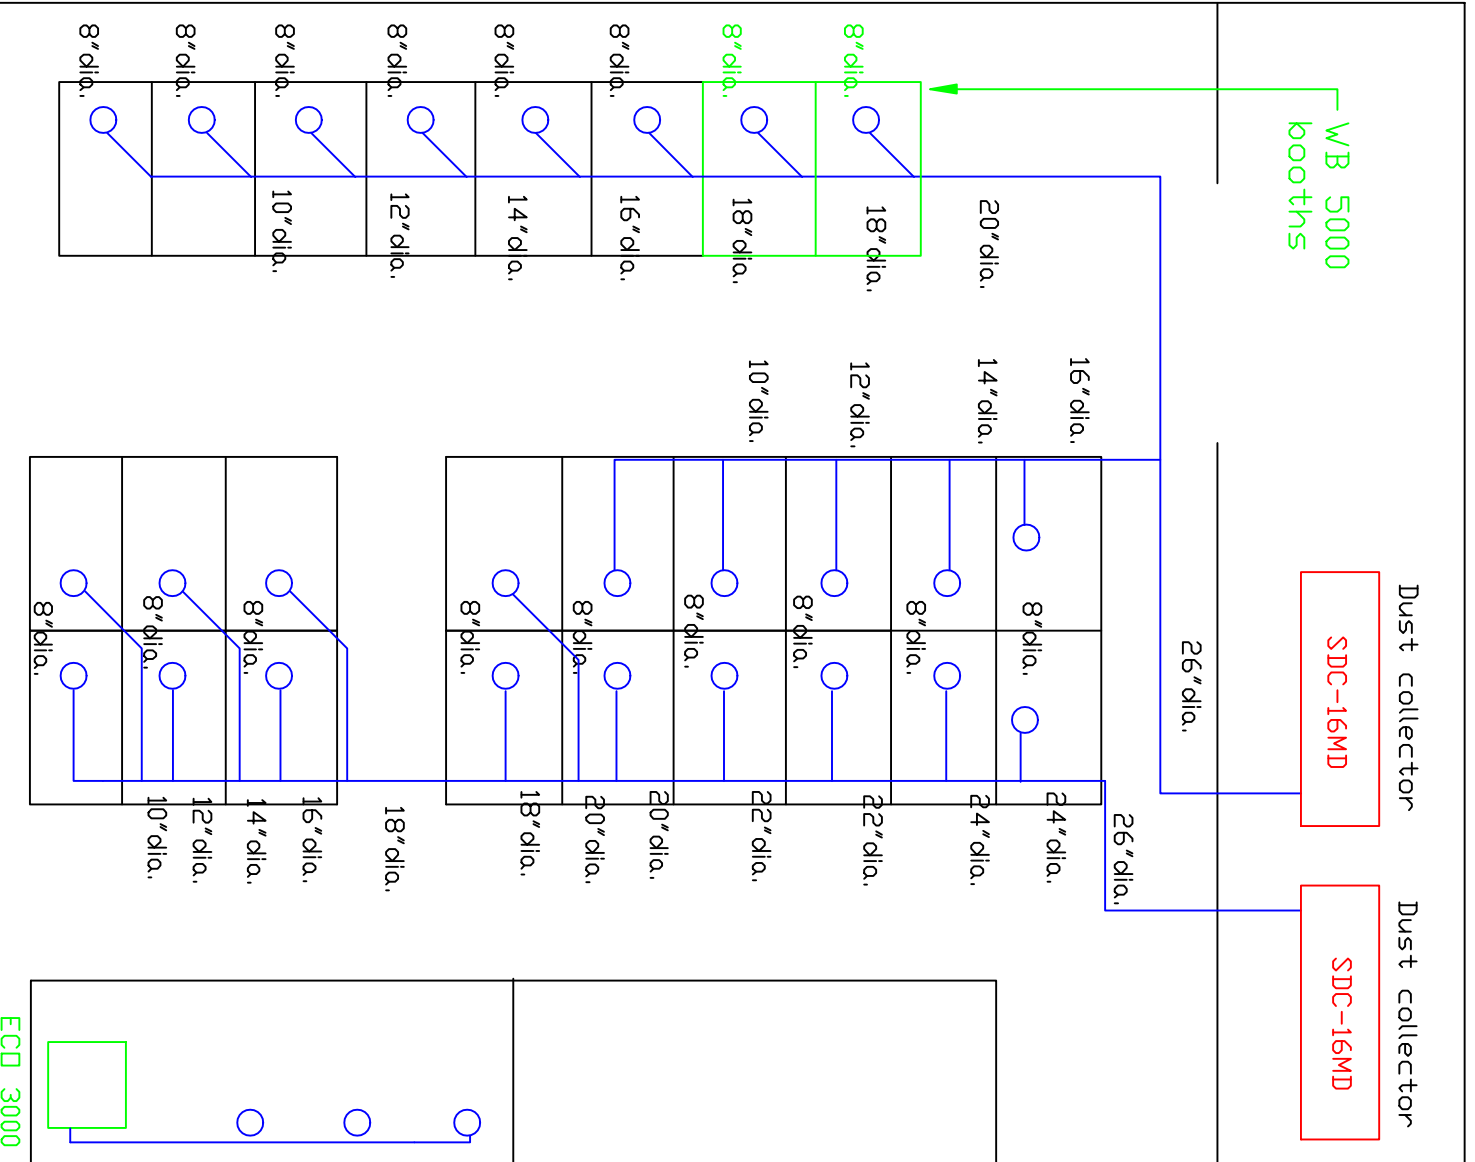

Avanti Environmental
 95 Cypress Drive 27596
 Youngsville, NC
 P# 919-570-2862 F# 919-570-2863
Avanti
 Project: Local 37 LA
 Drawing: Ductwork layout
 Date: 11/8/11 Drawn by: RAV
 Sheet No: