



## Ductwork Layout Plan View

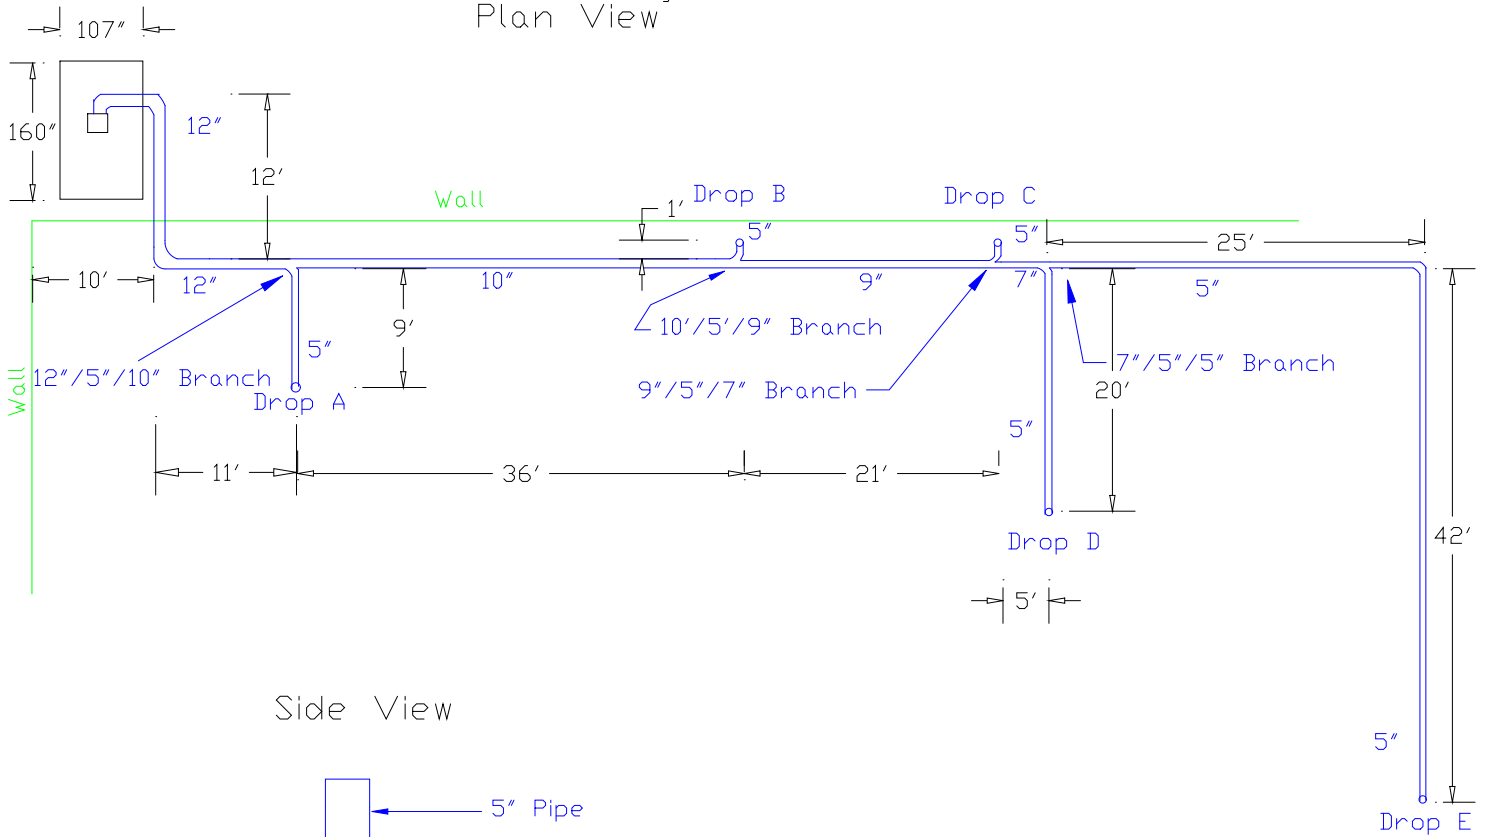

## Side View

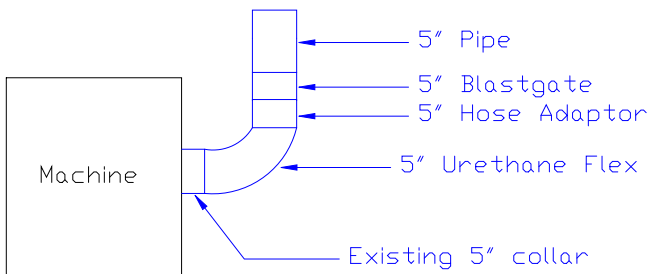

Industrial Air Quality	<b>IAQ</b>
102 AG DRIVE Youngsville, NC 27596 P# 919-562-7181 F# 919-562-7182	
Project: Clayton Homes, Waco	
Drawing: Ductwork Layout	
Date: 11/28/07 Drawn by: DDJ	
Revision Date:	