



# Absolent Ductwork Layout

DDR-3000

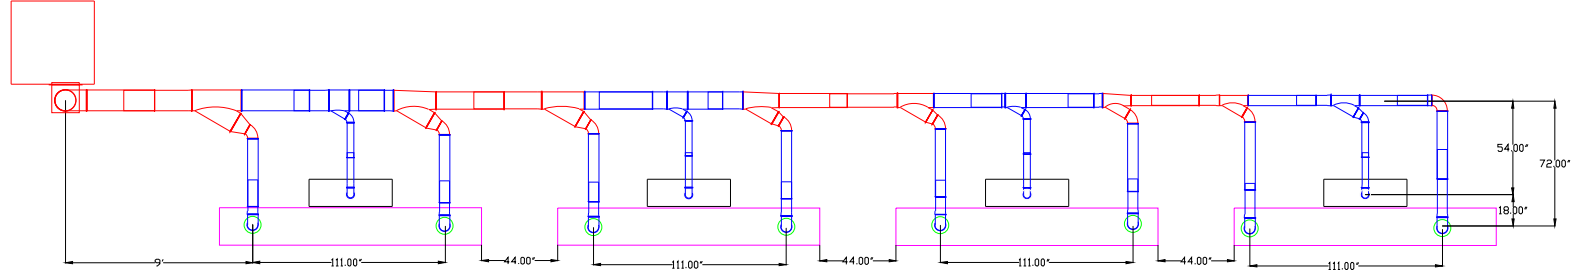

Plan View

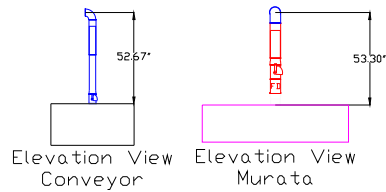

Notes:

1. All duct Jacobs Tubing
2. Re-use old lines while add new drops for conveyor belts.
3. Re-used tubing in RED
4. New tubing in BLUE

Avani Environmental Intl. Inc.  
 95 Cypress Drive  
 Youngsville, NC 27596  
 P# 919-570-2862 F# 919-570-2863

**Avani**

Project: DDR3000 New Layout

Drawing: Murata Project

Date: 11-5-12 Drawn by: MDT

Sheet No: