


Ductwork Layout for Absolent units

Side View

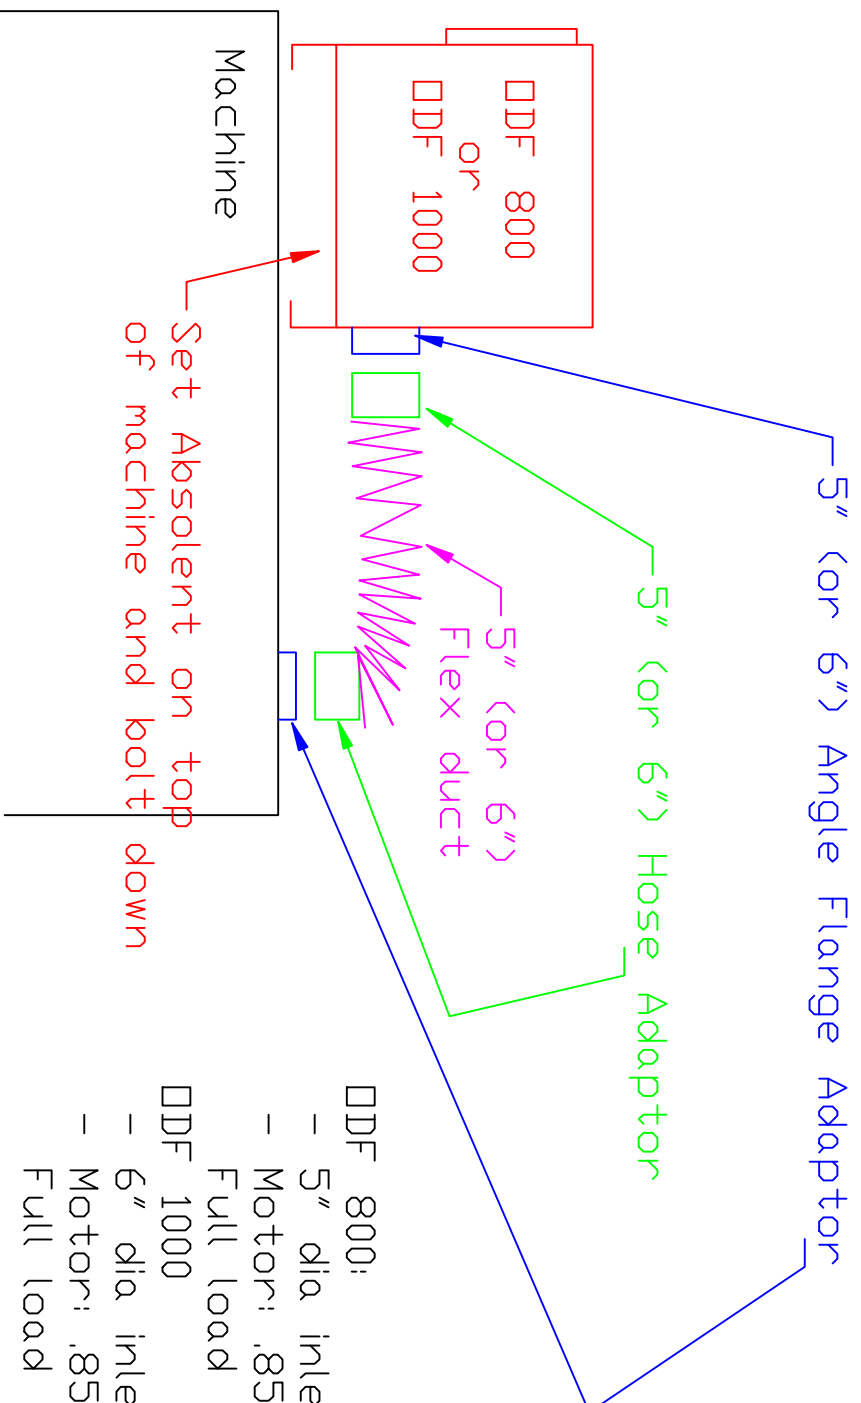

- DDF 800:
 - 5" dia inlet
 - Motor: .85HP 480 volts
 - Full load amps 1.4
- DDF 1000
 - 6" dia inlet
 - Motor: .85HP 480 volts
 - Full load amps 1.4

Note:
Plant voltage is a true 208 volts.

Industrial Air Quality 102 AG DRIVE Toungesville, NC 27596 PH 919-562-7181 F# 919-562-7182	IAQ
Project: DMC / Rabie	
Drawing: Ductwork layout	
Date: 9/9/09 Drawn by: RAV	
Sheet No:	