


# DDF 2000 Ductwork Layout

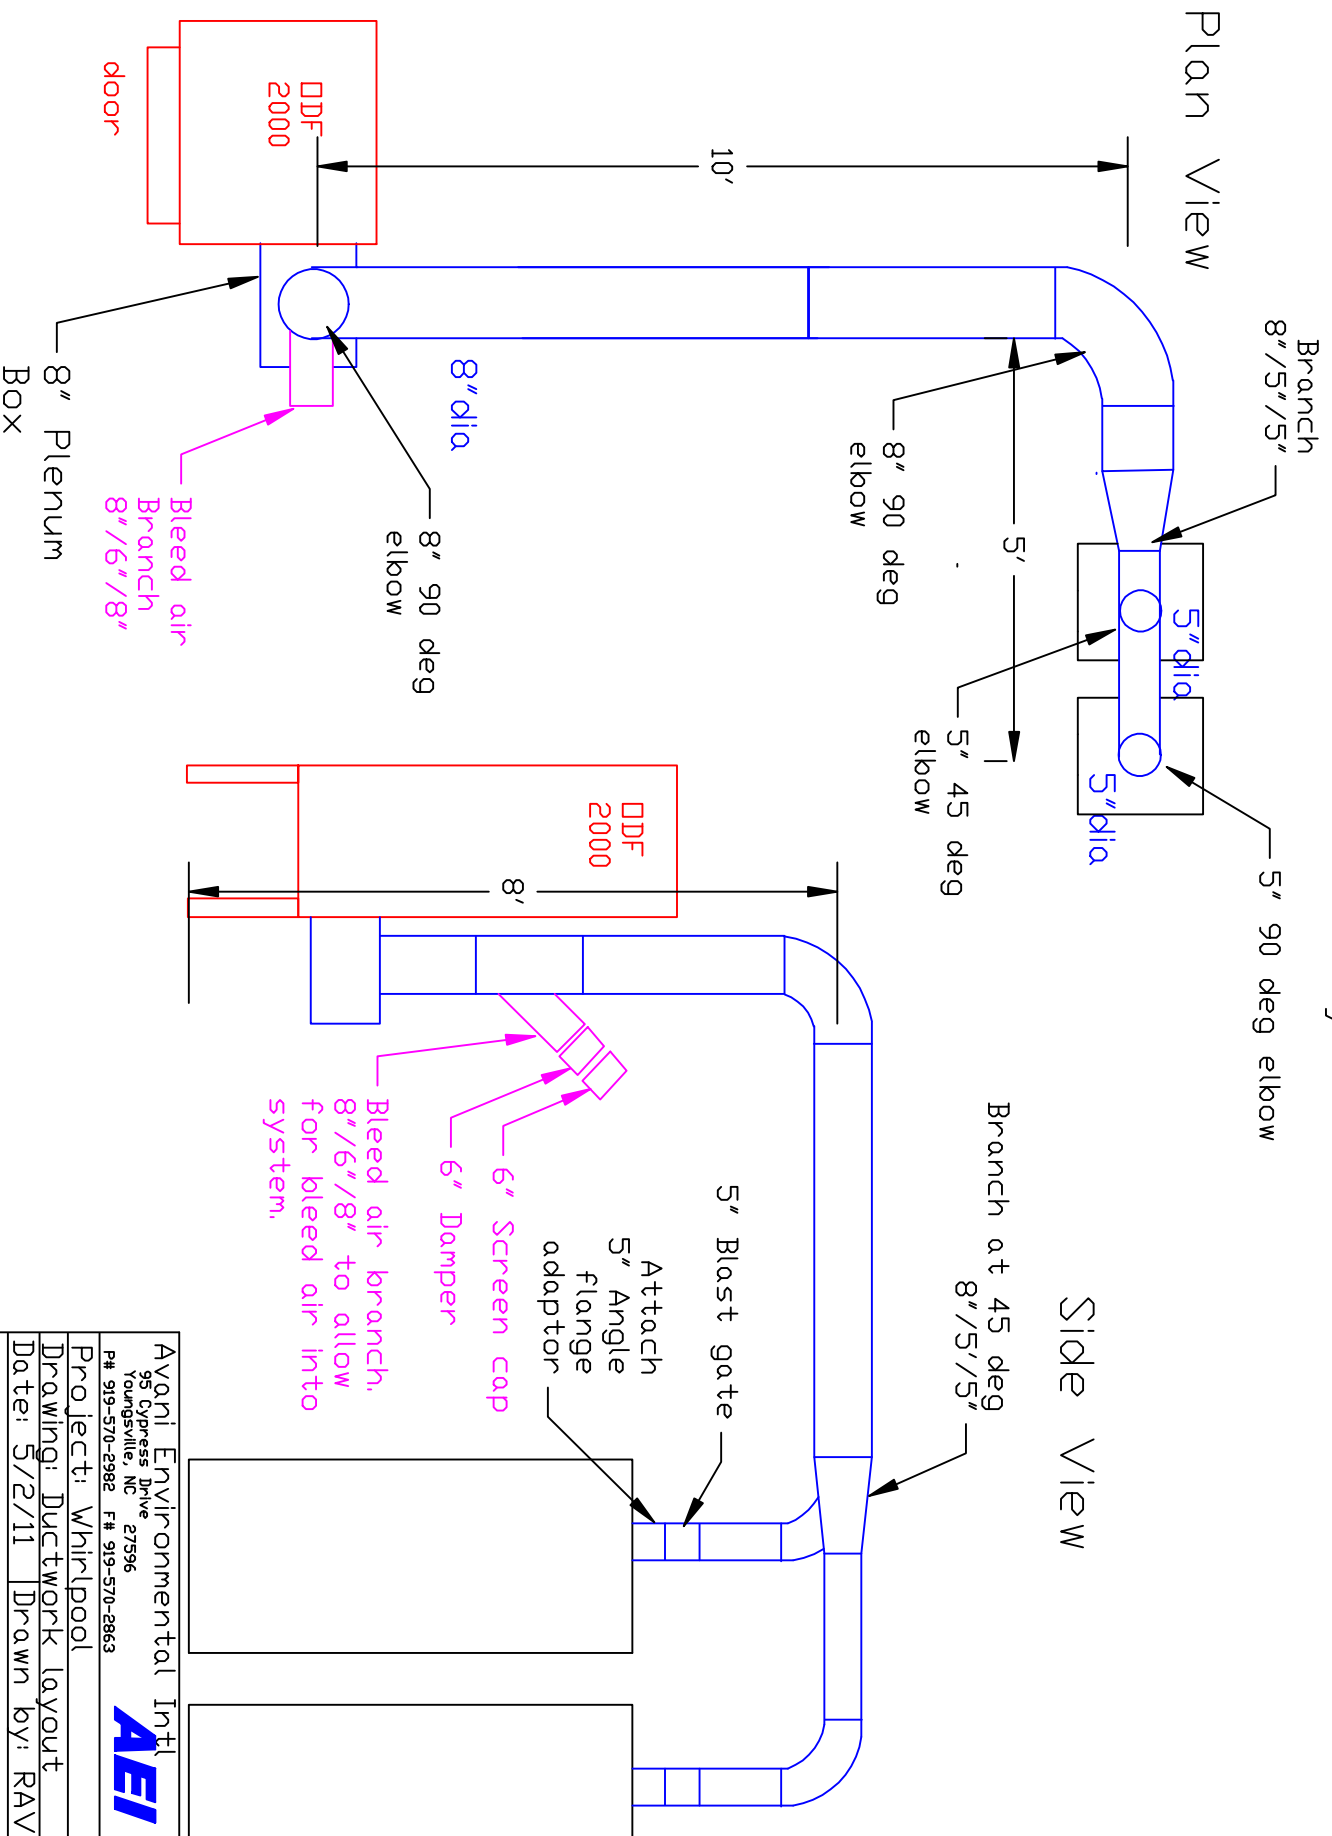

Avoni Environmental Int'l  
 95 Cypress Drive 27596  
 Youngsville, NC  
 P# 919-570-2982 F# 919-570-2863

Project: Whirlpool  
 Drawing: Ductwork layout  
 Date: 5/2/11 Drawn by: RAV  
 Sheet No:

