


Aksolent Ductwork Layout with Jacob Tucking

Side View

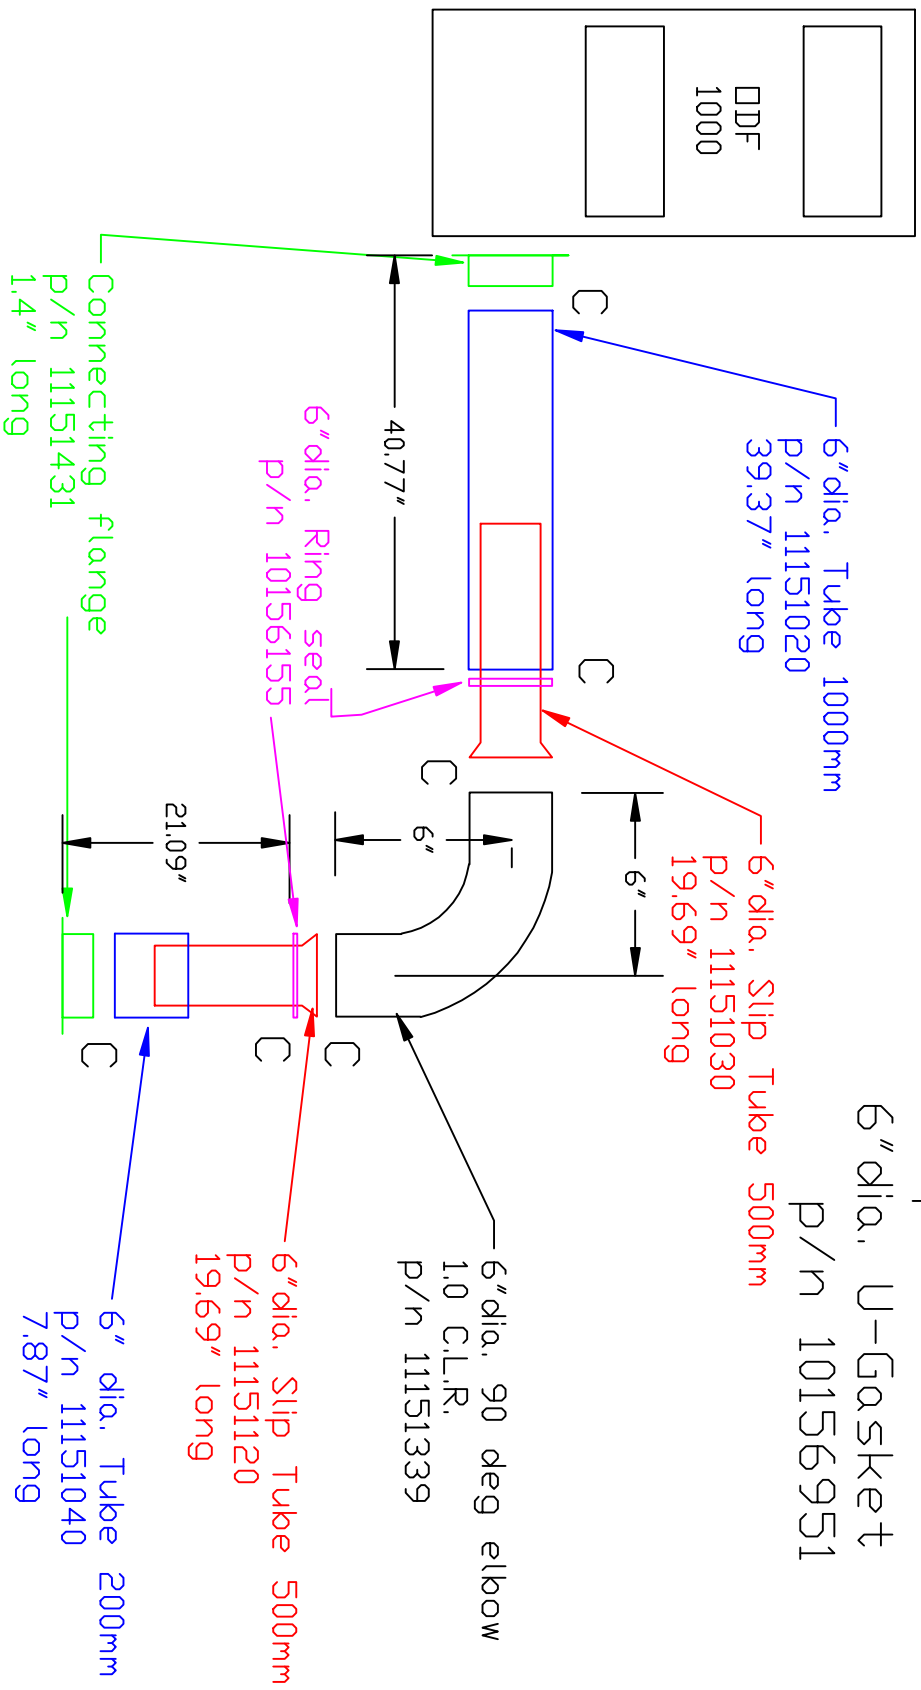

Avanti Environmental
95 Cypress Drive 27596
Roumbsville, NC
P# 919-570-2862 F# 919-570-2863

Avani

Project: Entrust Tool
Drawing: Ductwork layout
Date: 10/26/11 Drawn by: RAV
Sheet No: