


Revised Return Ductwork Layout Plan View

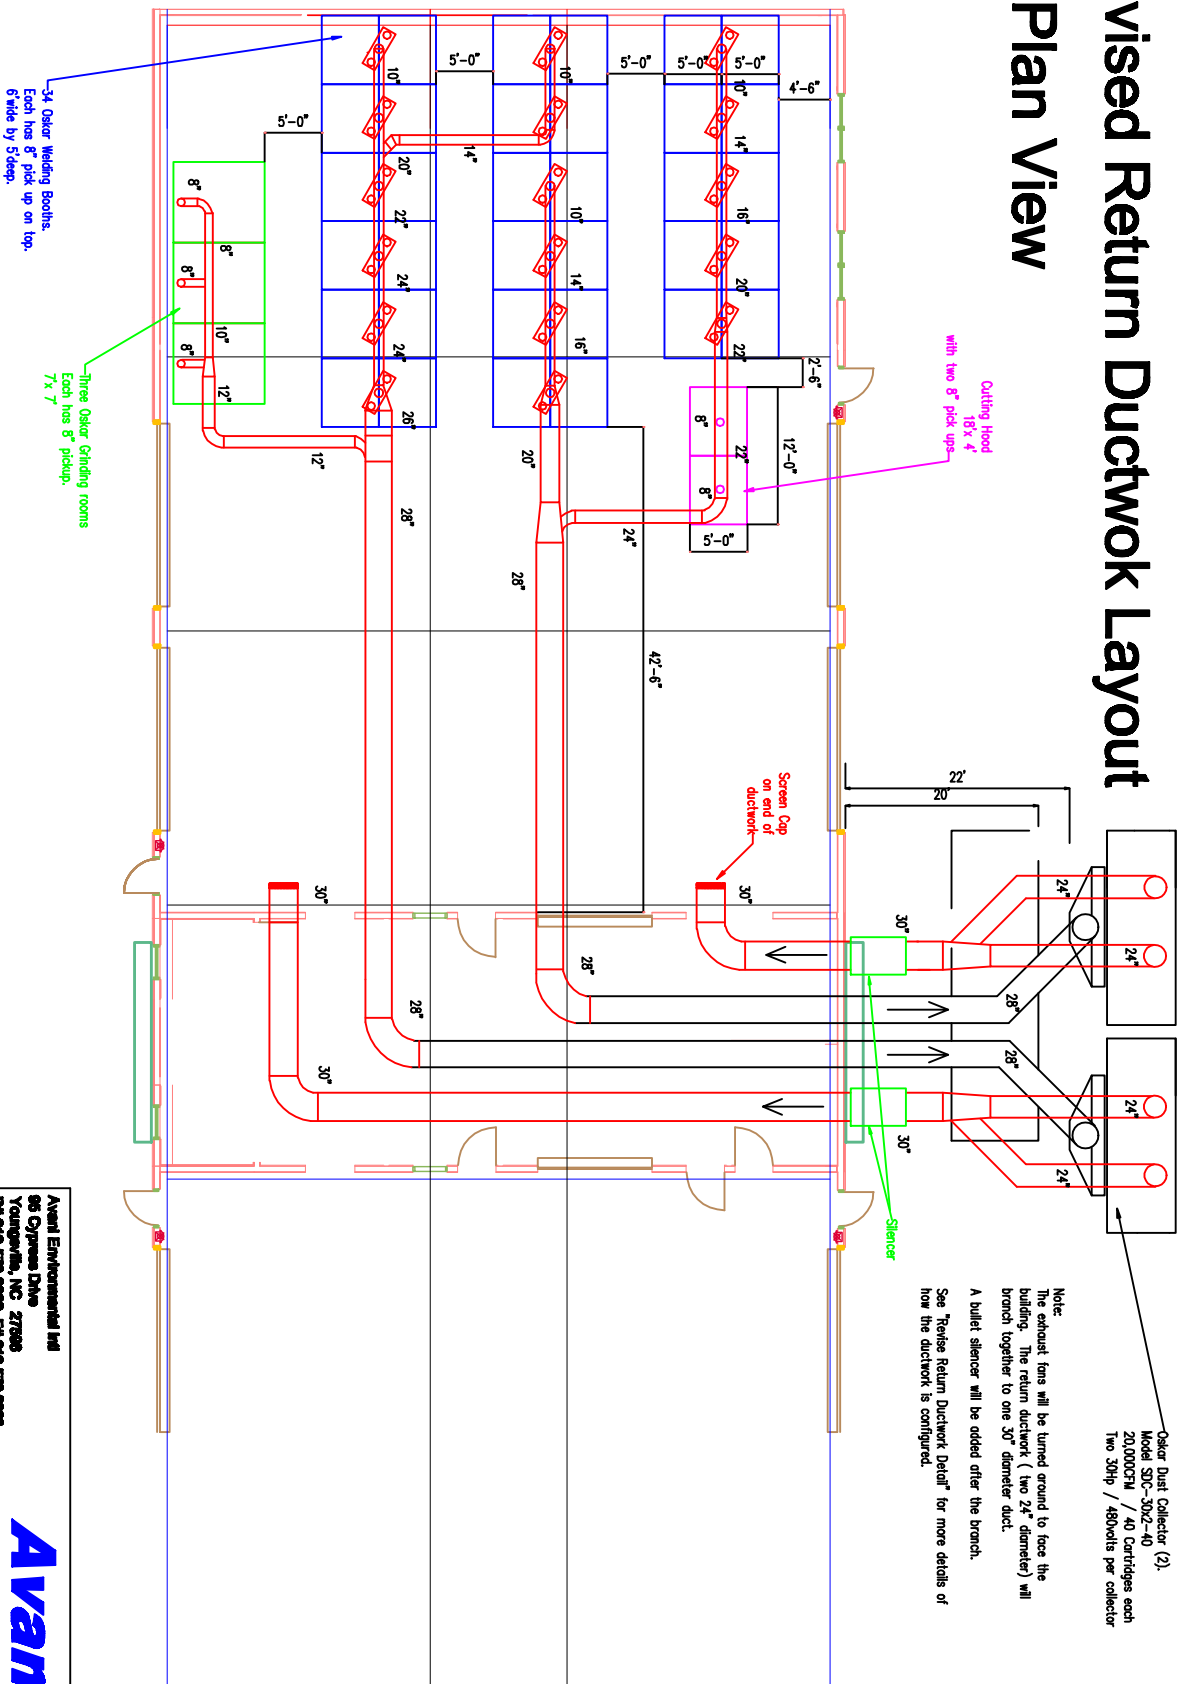

Avanti Environmental Int'l
96 Cypress Drive
Yountville, NC 27986
PH 918-870-2882 FX 918-870-2888



Project: Hartnell College

Drawing: Ductwork Layout

Date: 4/7/11

Drawn by: RAV

Sheet No: