


Booth Ductwork Layout Second Location Plan View

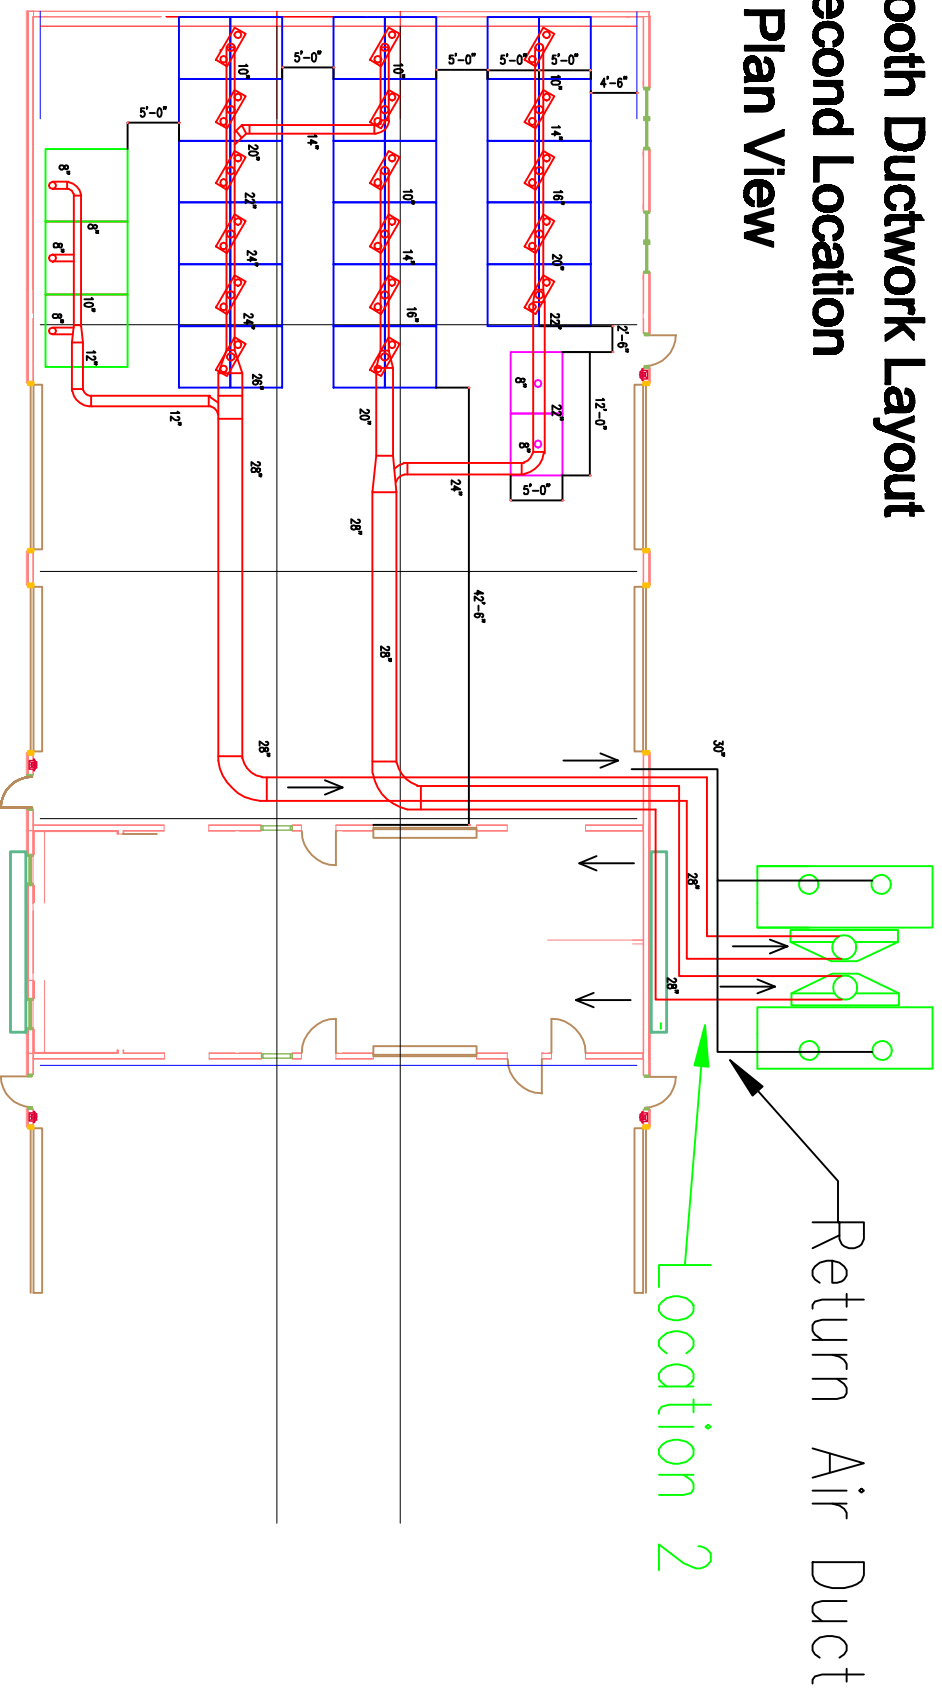

Avani Environmental 85 Cypress Drive Youngsville, NC 27596 919-870-2882 FX 919-870-2883		
Project: Hartnell College		
Drawing: Ductwork Layout		
Date:	Drawn by: RAV	
Sheet No:		